




Four Dormitory Complex  
East Healey Street,  
Champaign,  
Illinois,  
USA

**Prairie Sky Consulting**

1104 Parkview Drive  
Mahomet  
Illinois  
USA 61853


Email: bill\_east@prairieskyconsulting.com  
Phone: 309 - 807 - 1519  
Web: www.prairieskyconsulting.com/

Keynote	Family
25 35 16.A	Ceiling Daylight Sensor - Regular Voltage
26 24 16.A	Control Panel
26 29 00.A	Temperature Sensor

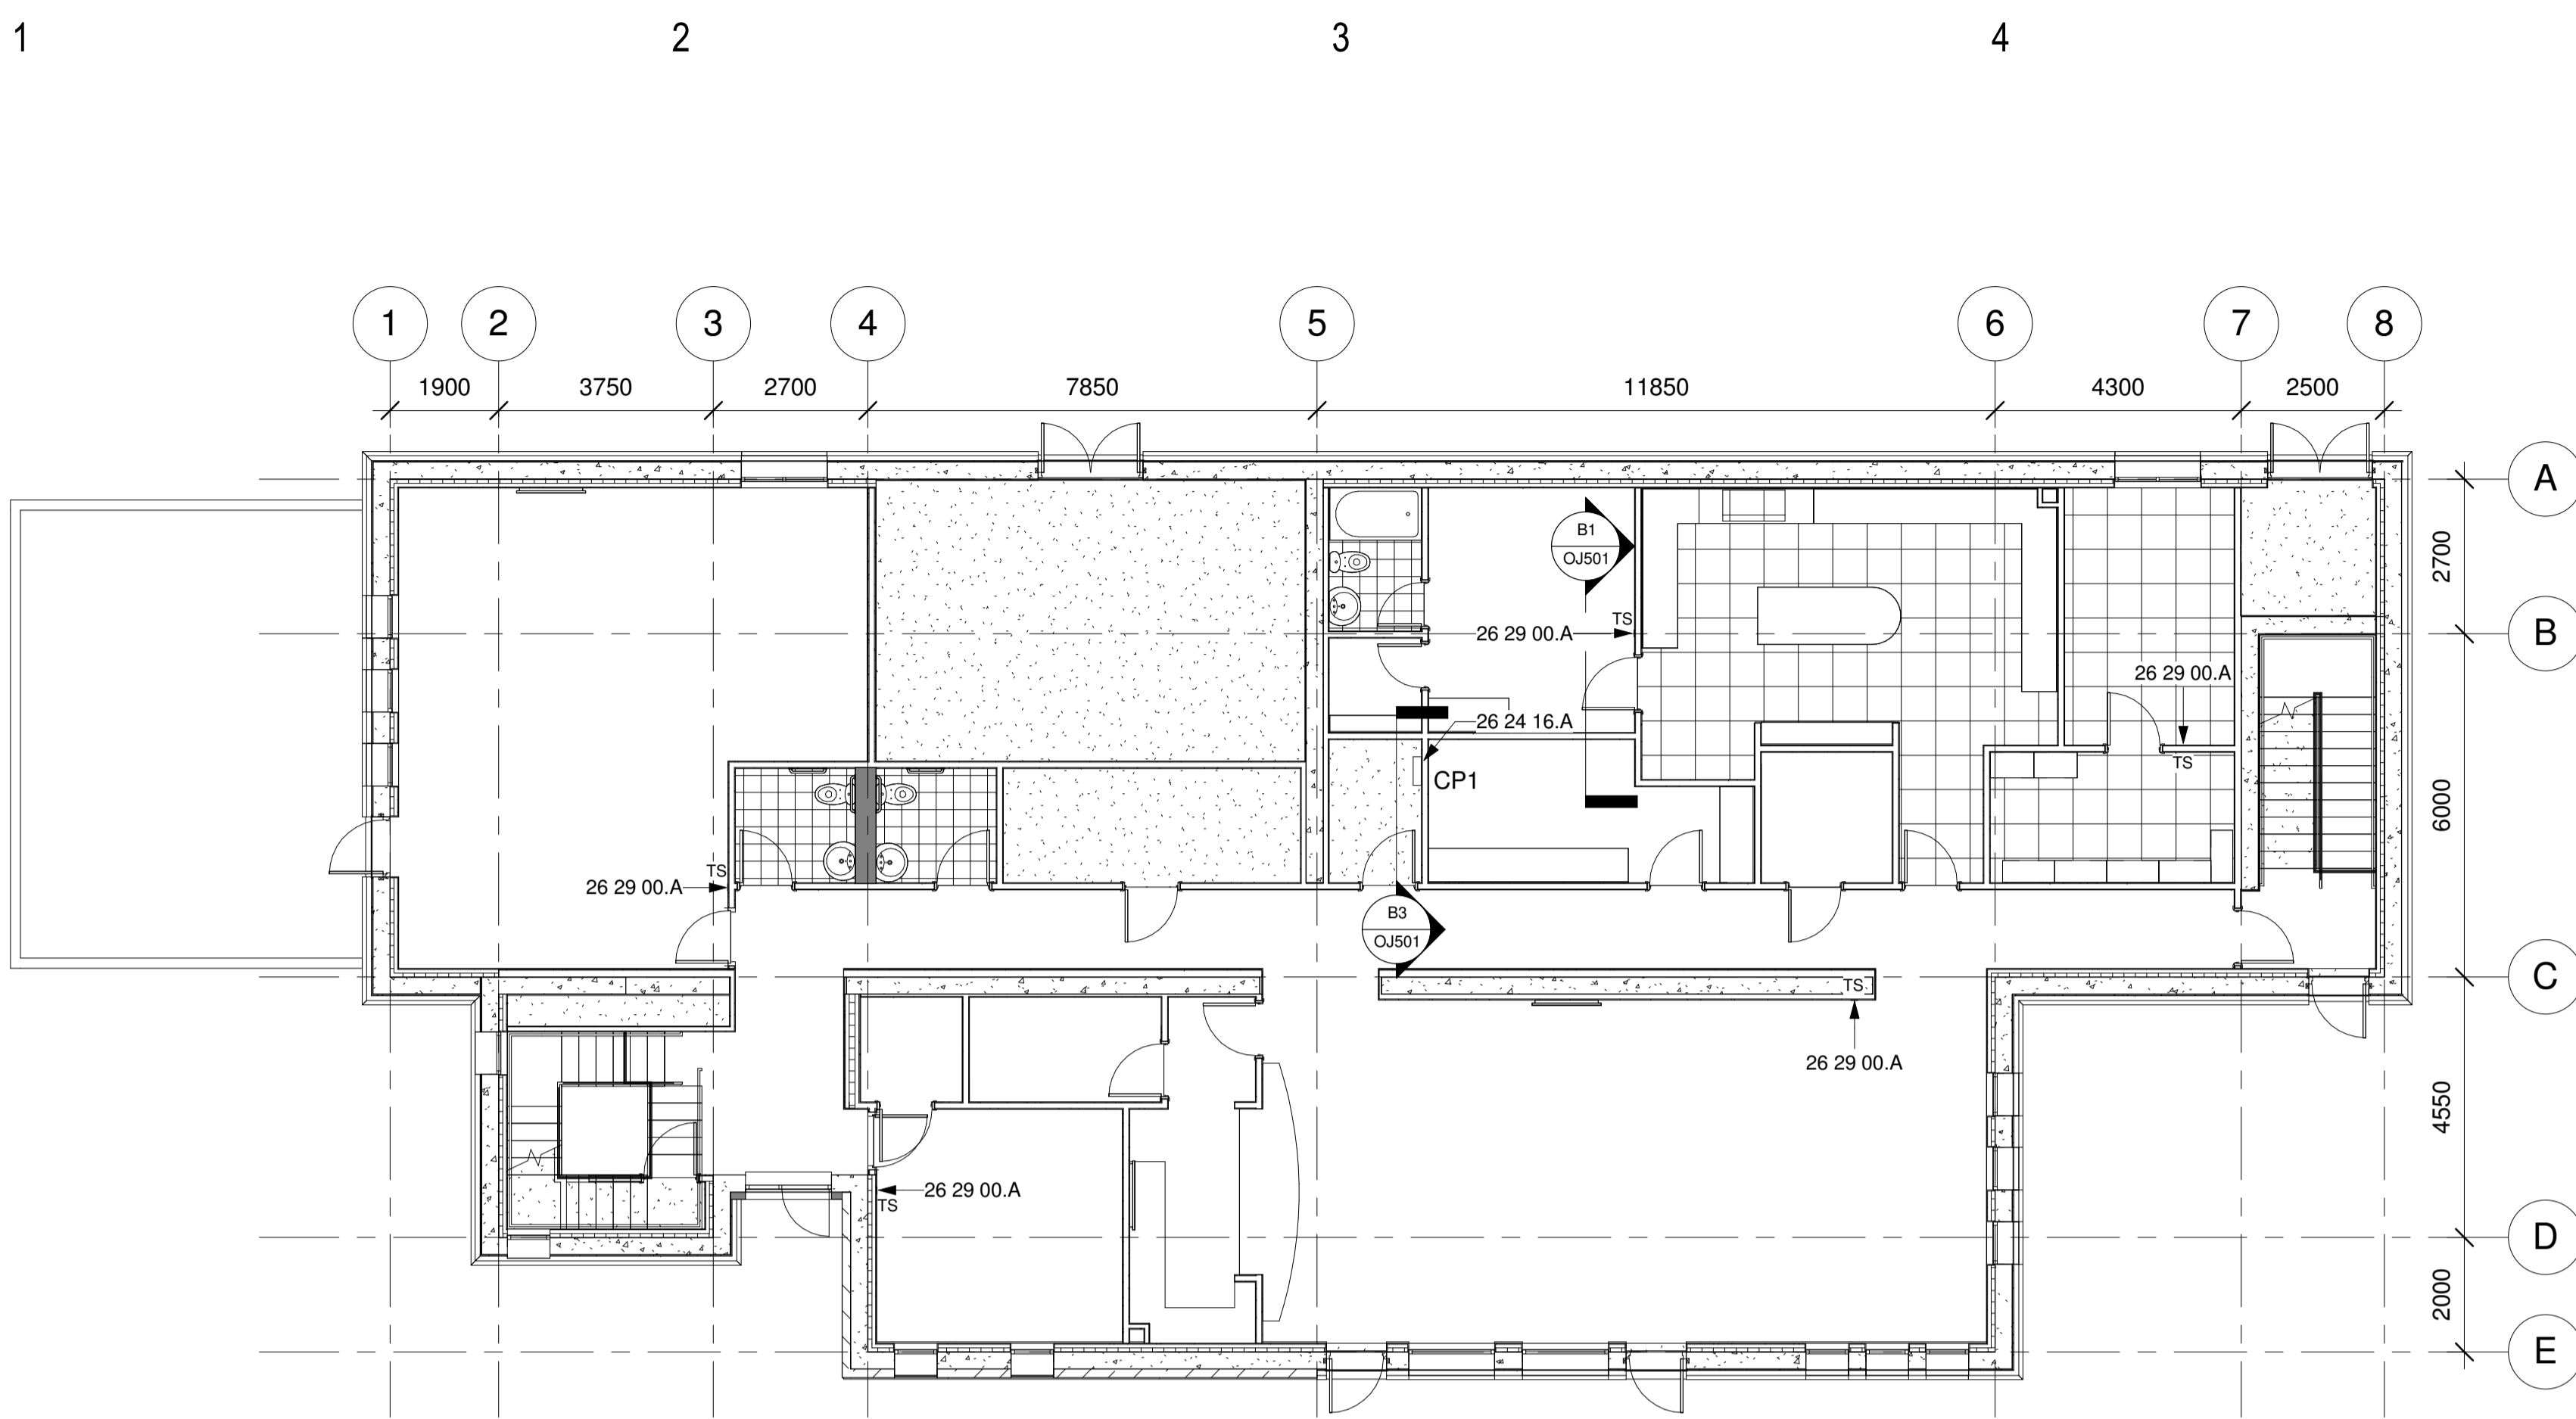

**C1** Level 1 Floor Plan

1 : 100

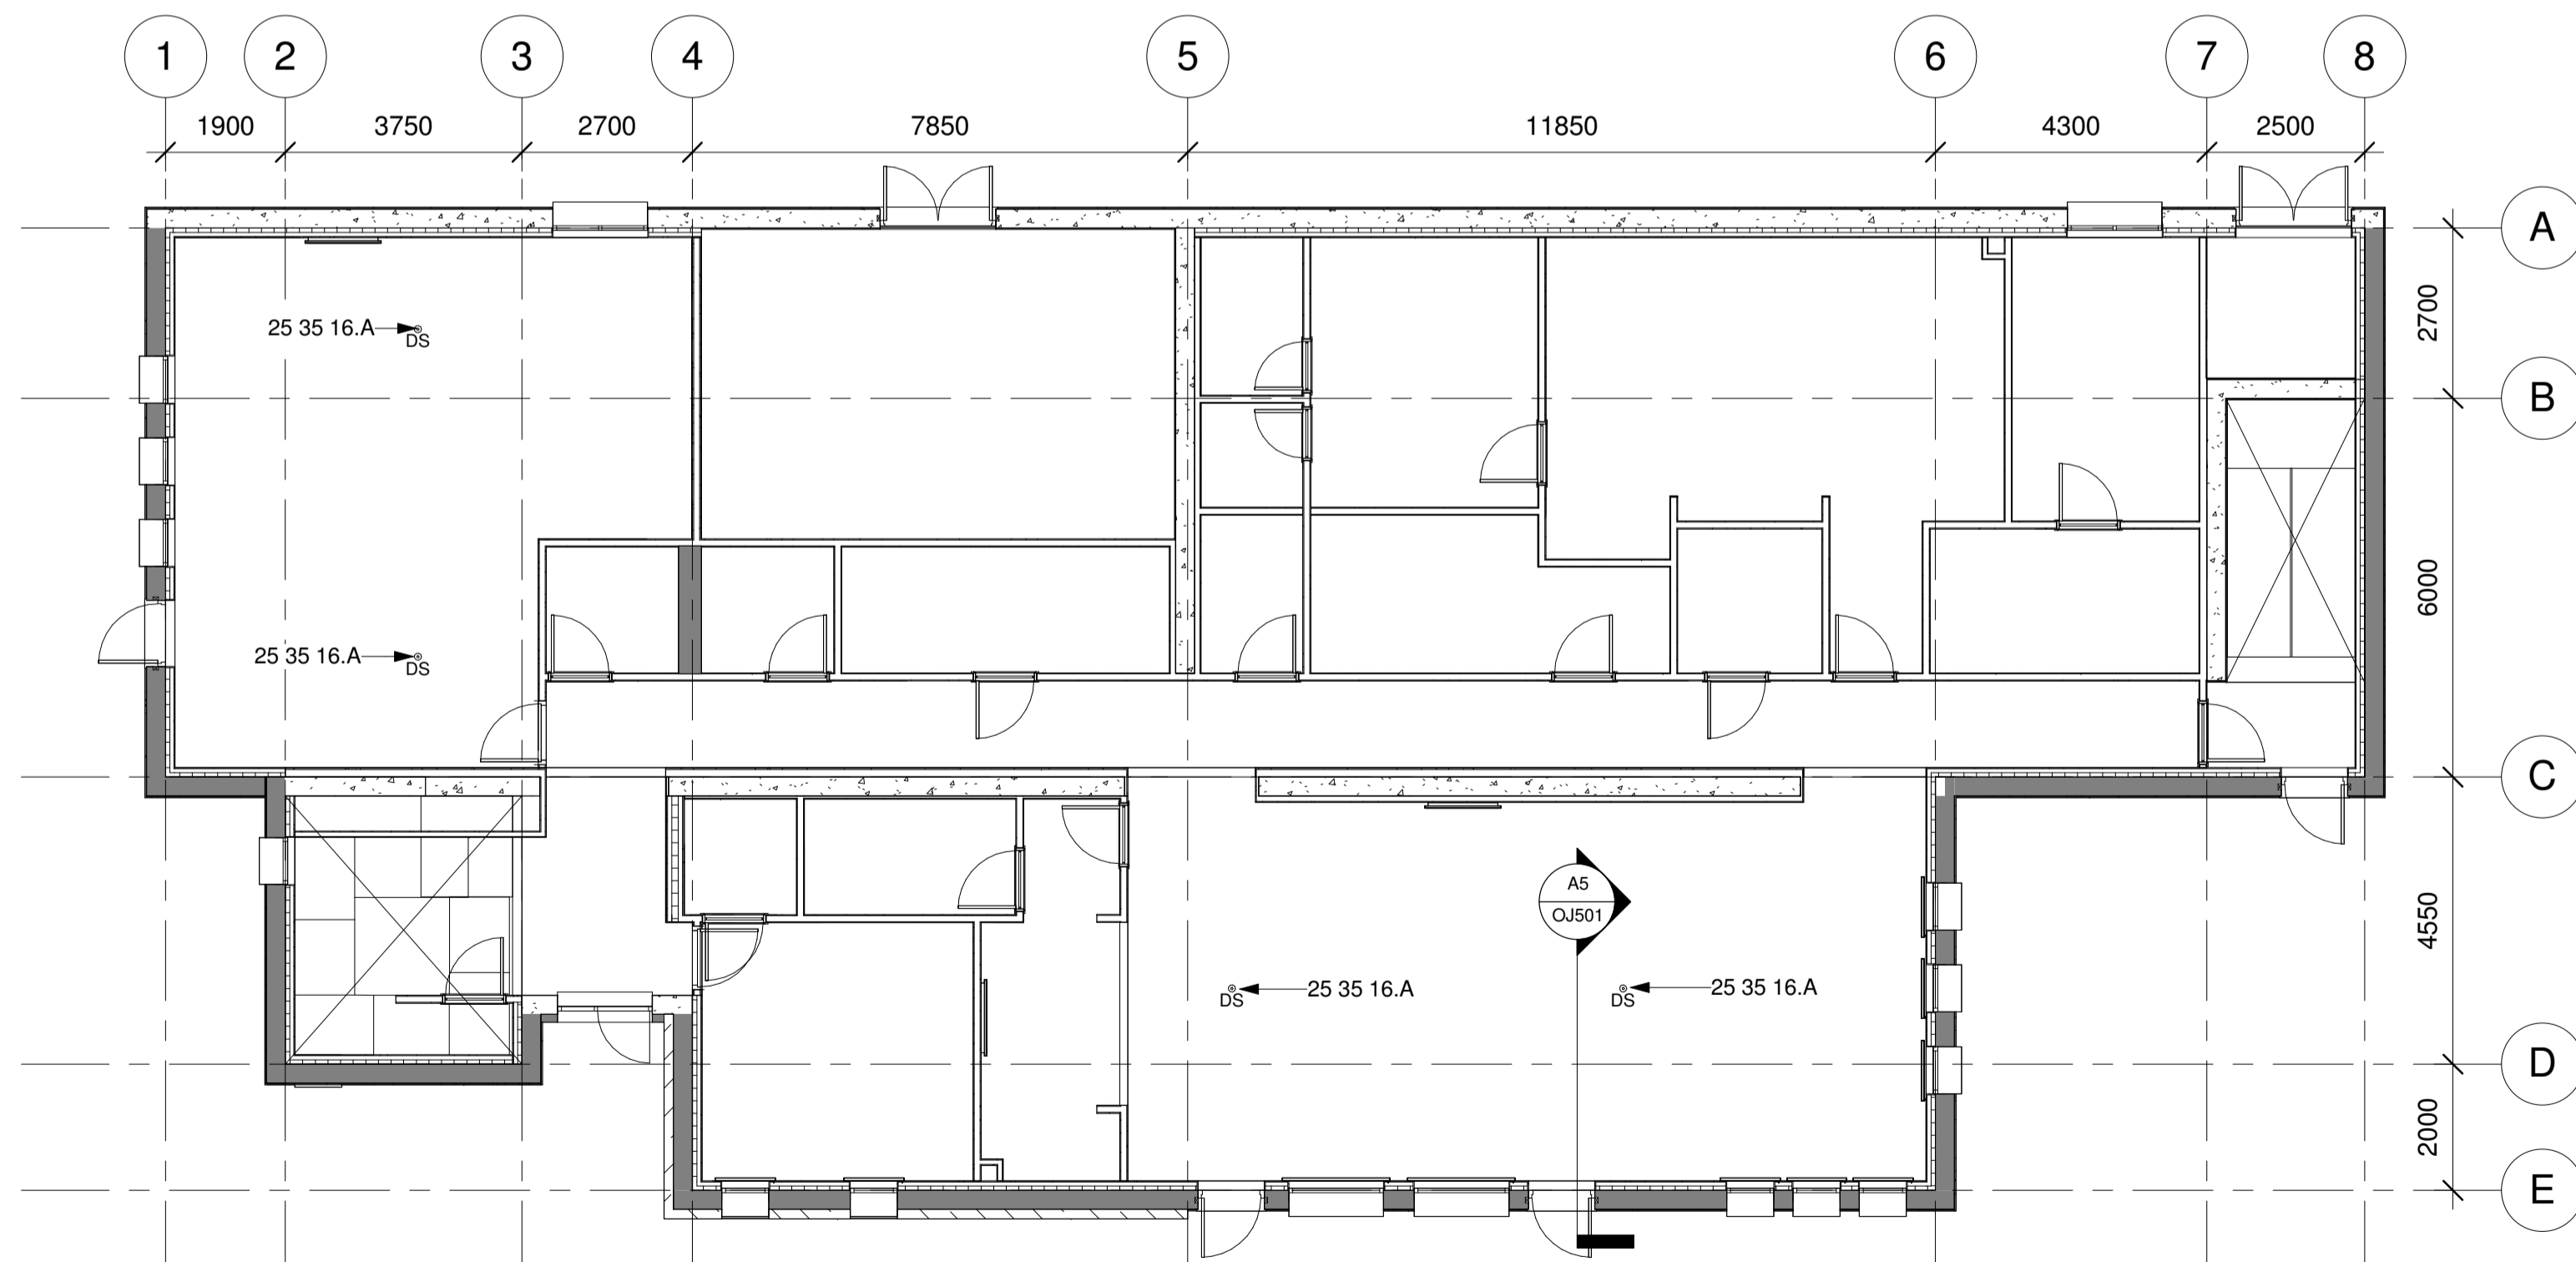

**A1** Level 1 Ceiling Plan

1 : 100

REV	DATE	DESCRIPTION
4	21.07.17	Final Issue
3	03.07.17	Spaces Revised
2	27.06.17	Keynotes Revised
1	01.06.17	Issued For Review

PROJECT NUMBER	East Dormitory
DRAWN BY	R.K.
CHECKED BY	B.E.
SCALE (@ A1)	1 : 100
DATE	04/06/17
STATUS	Final Issue
REVISION	4

PROJECT	Four Dormitory Complex
TITLE	Level 1 Floor Plan
	OJ101
	SHEET 1 OF 4

THIS DESIGN IS NOT INTENDED TO MEET THE BUILDING CODES OR REGULATIONS OF ANY SPECIFIC COUNTRY OR JURISDICTION.

SOME COMPONENTS HAVE BEEN OMITTED AS THE DESIGN WAS MODELLED EXCLUSIVELY USING OUT OF THE BOX REVIT FAMILIES.

THIS DRAWING IS THE PROPERTY OF MMA ENVIRONMENTAL AND SHALL NOT BE USED, REPRODUCED OR DISCLOSED TO ANYONE WITHOUT THE PRIOR WRITTEN PERMISSION OF MMA ENVIRONMENTAL.