


C1 Level 2 Floor Plan
1 : 100

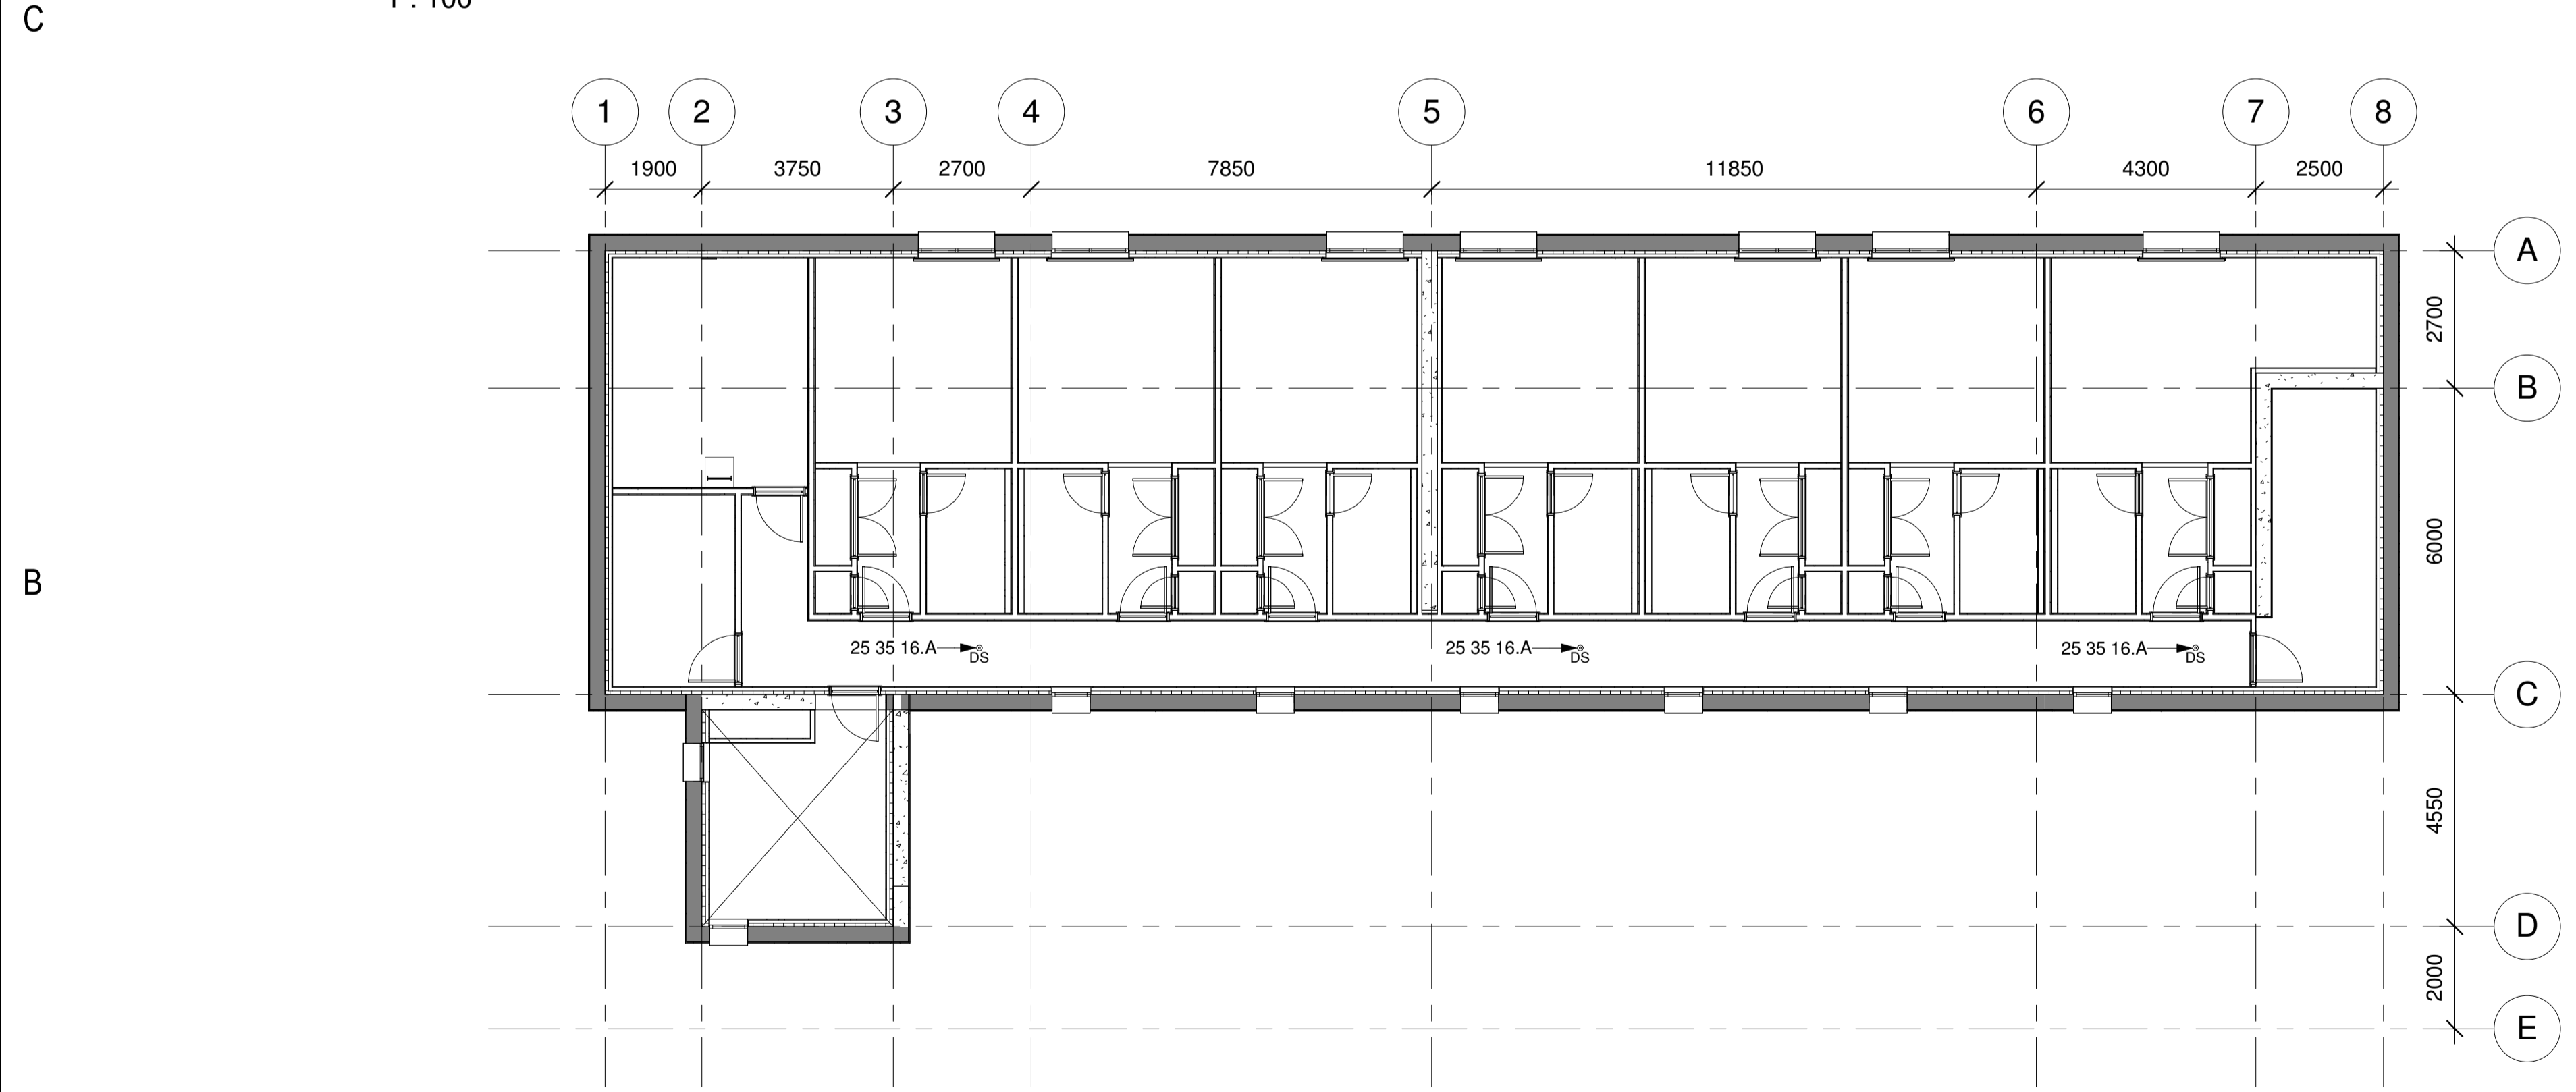

A1 Level 2 Ceiling Plan
1 : 100

THIS DESIGN IS NOT INTENDED TO MEET THE BUILDING CODES OR REGULATIONS OF ANY SPECIFIC COUNTRY OR JURISDICTION.
SOME COMPONENTS HAVE BEEN OMITTED AS THE DESIGN WAS MODELLED EXCLUSIVELY USING OUT OF THE BOX REVIT FAMILIES.

MMA ENVIRONMENTAL
M&E Consulting Engineers

4E Fingal Bay Business Park
Balbriggan
Co. Dublin
K32 HN62
Ireland

Email: info@mma.ie
Phone: +353 1 6905040
Web: www.mma.ie

CERTIFIED
iNet
MANAGEMENT SYSTEM

NSAI
Quality
NSAI Certified

ACEI ASSOCIATION OF
CONSULTING ENGINEERS
OF IRELAND

Four Dormitory Complex
East Healey Street,
Champaign,
Illinois,
USA

Prairie Sky Consulting

1104 Parkview Drive
Mahomet
Illinois
USA 61853

Email: bill.east@prairieskyconsulting.com
Phone: 309 - 807 - 1519
Web: www.prairieskyconsulting.com/

REV	DATE	DESCRIPTION
4	21.07.17	Final Issue
3	03.07.17	Spaces Revised
2	27.06.17	Keynotes Revised
1	01.06.17	Issued For Review

PROJECT NUMBER	East Dormitory
DRAWN BY	R.K.
CHECKED BY	B.E.
SCALE (@ A1)	1 : 100
DATE	04/11/17
STATUS	Final Issue
REVISION	4

PROJECT	Four Dormitory Complex
TITLE	Level 2 Floor Plan
	OJ102
	SHEET 2 OF 4

THIS DRAWING IS THE PROPERTY OF MMA ENVIRONMENTAL AND SHALL NOT BE USED, REPRODUCED OR DISCLOSED TO ANYONE WITHOUT THE PRIOR WRITTEN PERMISSION OF MMA ENVIRONMENTAL.