




Four Dormitory Complex
East Healey Street,
Champaign,
Illinois,
USA

Prairie Sky Consulting


1104 Parkview Drive
Mahomet
Illinois
USA 61853

Email: bill.east@prairieskyconsulting.com
Phone: 309 - 807 - 1519
Web: www.prairieskyconsulting.com/

Keynote	Family
10 44 16.13.A	Fire Extinguisher
21 11 19.A	Fire Department Inlet Connection - 3 Way - Flush Plate
21 13 13.A	Sprinkler - Dry - Pendant - Hosted
21 13 13.B	Sprinkler - Dry - Horizontal Sidewall - Hosted
28 31 23.A	Fire Alarm Control Panel
28 31 43.A	Heat Detector
28 31 46.A	Smoke Alarm
28 31 53.13.A	Fire Alarm Break Glass Unit
28 31 63.13.A	Fire Alarm Sounder

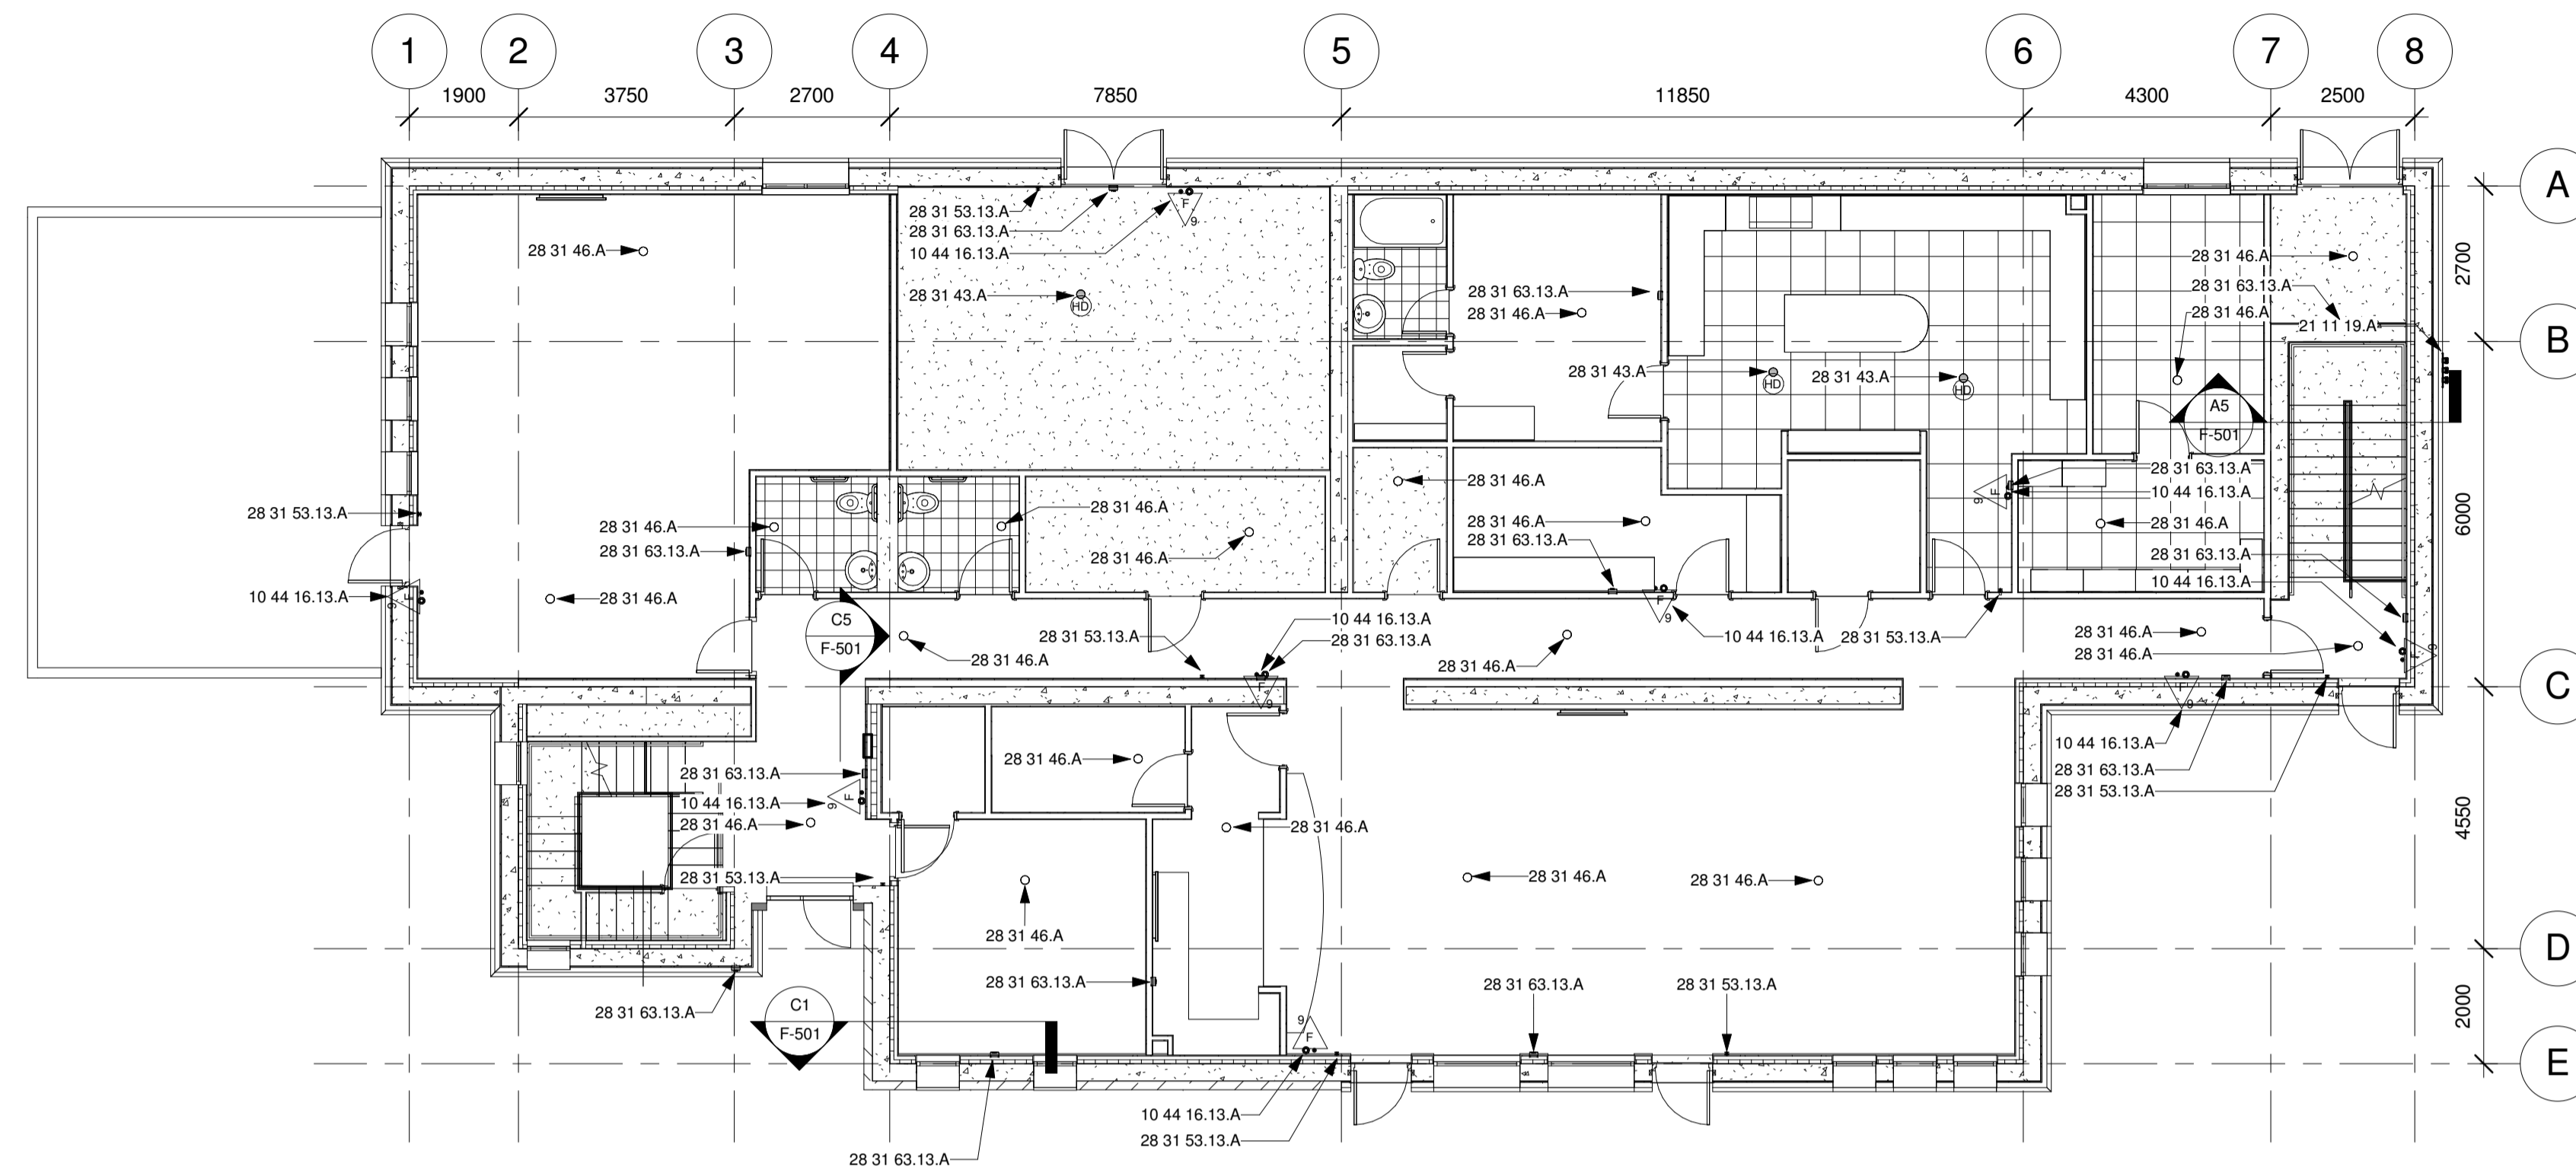

C2 Level 1-Fire Alarm System
1 : 100

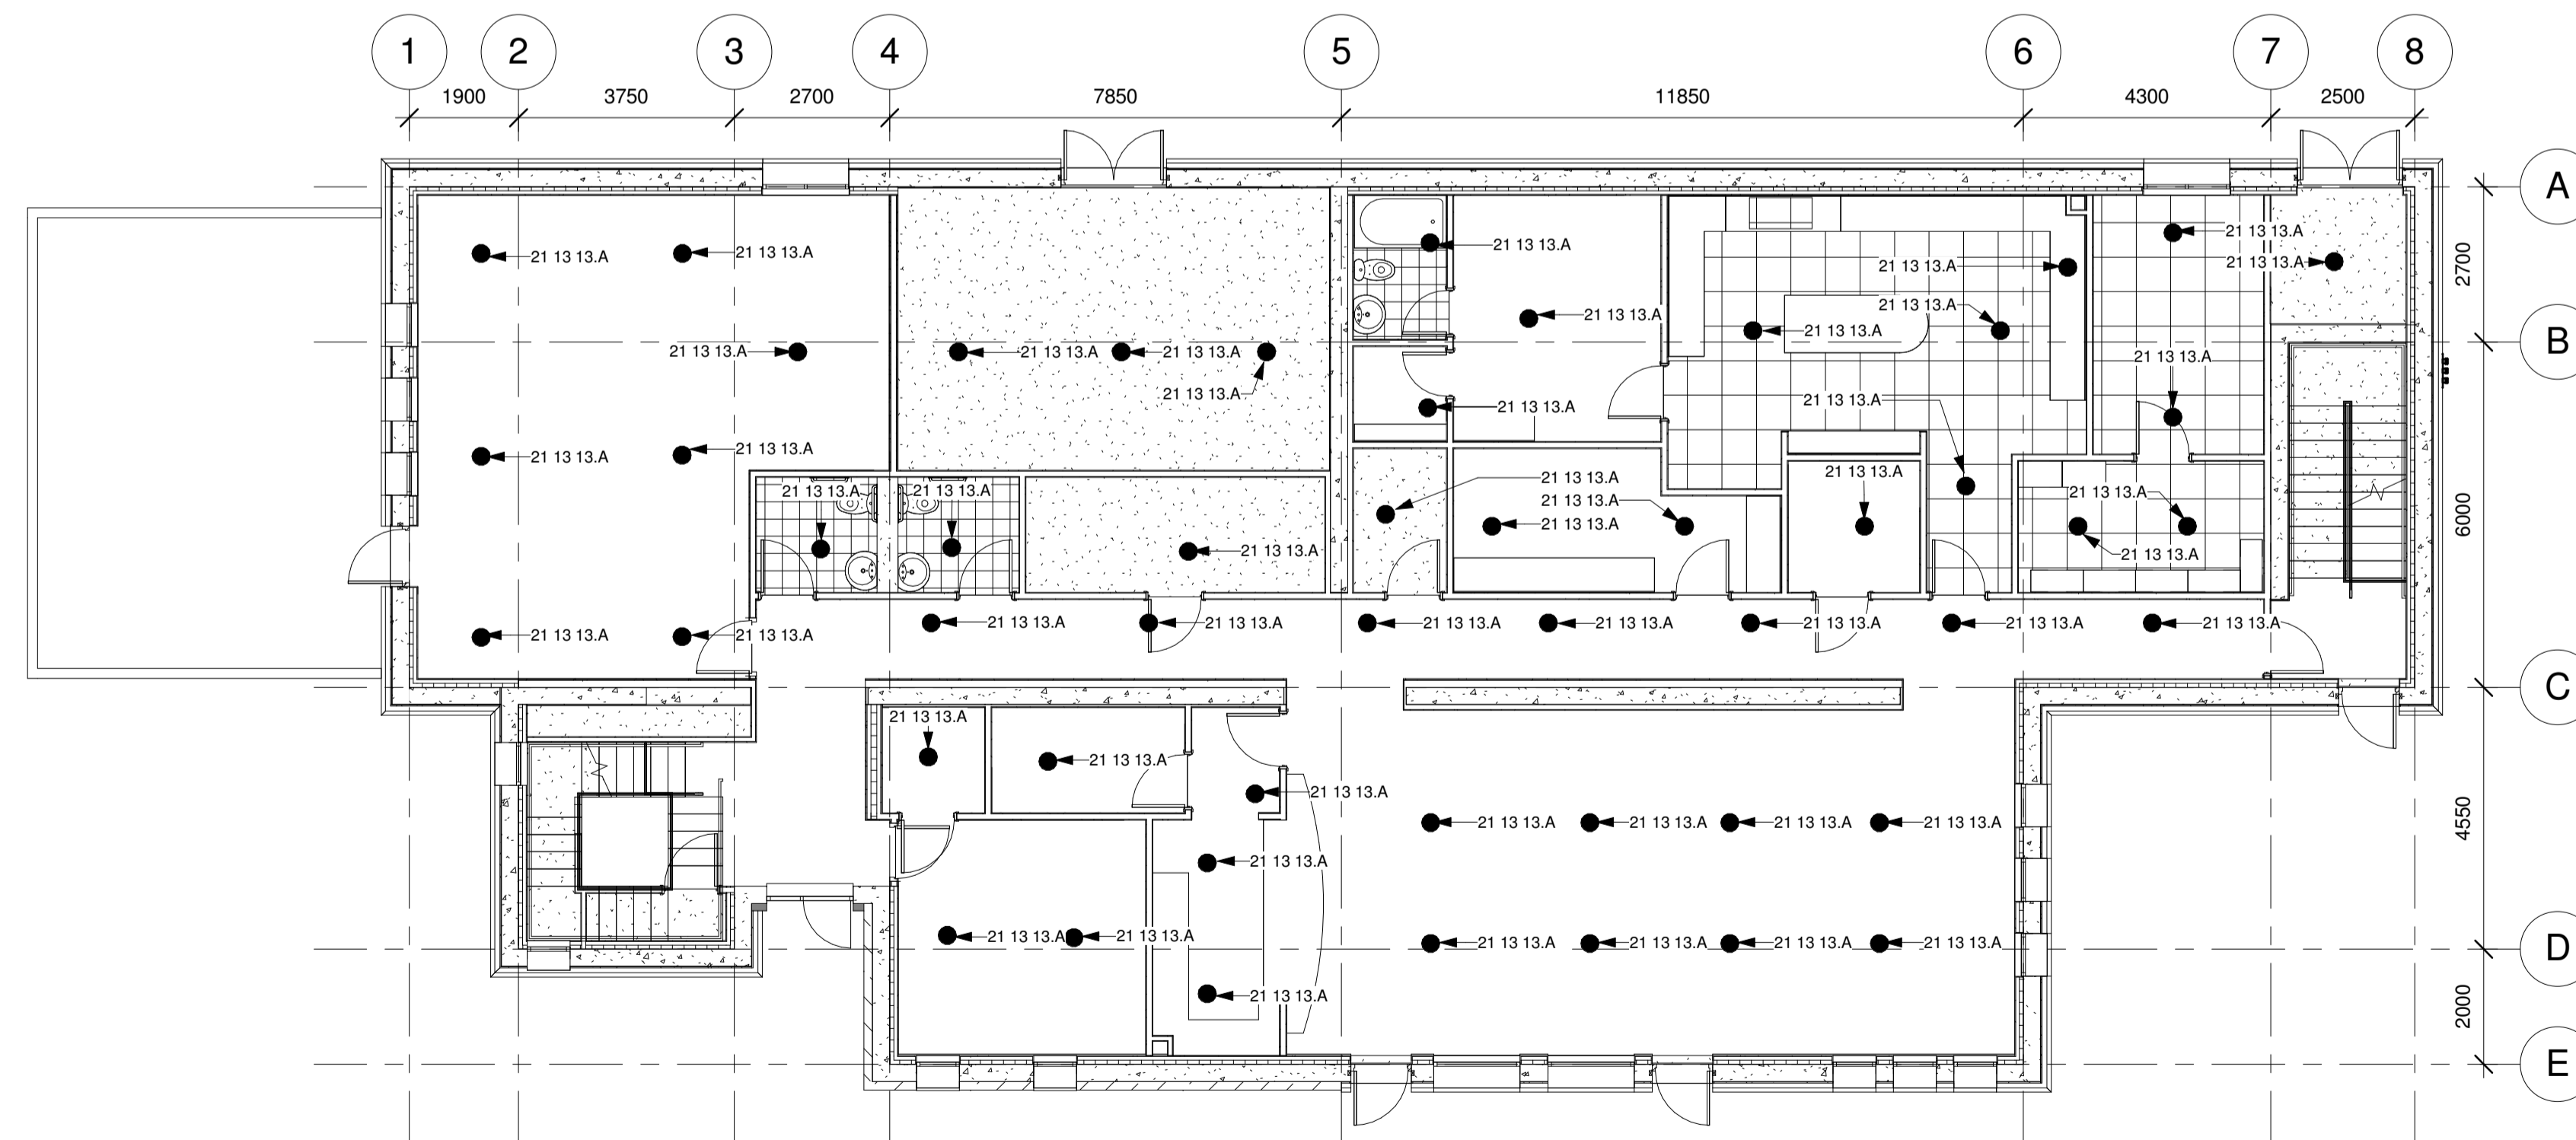

A2 Level 1-Sprinkler System
1 : 100

THIS DESIGN IS NOT INTENDED TO MEET THE BUILDING CODES OR REGULATIONS OF ANY SPECIFIC COUNTRY OR JURISDICTION.

SOME COMPONENTS HAVE BEEN OMITTED AS THE DESIGN WAS MODELLED EXCLUSIVELY USING OUT OF THE BOX REVIT FAMILIES.

REV	DATE	DESCRIPTION
5	21.07.17	Final Issue
4	04.07.17	Spaces Revised
3	20.06.17	Keynotes Revised
2	31.06.17	Issued for 2nd Review
1	26.05.17	Issued for Review

PROJECT NUMBER	East Dormitory
DRAWN BY	R.K.
CHECKED BY	B.E.
SCALE (@ A1)	1 : 100
DATE	05/11/17
STATUS	Final Issue
REVISION	5

PROJECT	Four Dormitory Complex
TITLE	Level 1 Floor Plan
	F-101
	SHEET 1 OF 4

THIS DRAWING IS THE PROPERTY OF MMA ENVIRONMENTAL AND SHALL NOT BE USED, REPRODUCED OR DISCLOSED TO ANYONE WITHOUT THE PRIOR WRITTEN PERMISSION OF MMA ENVIRONMENTAL.