




Four Dormitory Complex
East Healey Street,
Champaign
Illinois
USA

Prairie Sky Consulting

1104 Parkview Drive
Mahomet
Illinois
USA 61853
Email: bill.east@prairieskyconsulting.com
Phone: 309 - 807 - 1519
Web: www.prairieskyconsulting.com/

21_All Equipment Schedule	
Keynote	Family
01 51 36.A	Tap
10 28 13.13.A	Toilet
10 28 16.13.A	Bath Tub
22 05 23.A	Shower Valve
22 14 26.13.A	Roof Drain
22 14 26.16.A	Floor Drain - Round
22 41 00.A	Shower Head
22 42 16.A	Lavatory - Vanity
22 42 16.B	Lavatory - Vanity 1200 750m
22 42 23.A	Shower Basin
22 46 16.A	Sink - Island - Single
22 46 16.B	Sink - Kitchen - Double
23 09 13.33.A	Gate Valve
25 35 19.A	Motor Control Valve
33 44 19.16.A	Lavatory - Wall Mounted
40 05 13.13.A	PLU-BallValve
40 05 13.13.B	PLU-BallValve
40 05 13.13.C	PLU-BallValve
40 05 13.13.D	PLU-BallValve
40 05 13.13.E	PLU-BallValve
40 05 23.13.A	RPZ Valve
40 92 13.A	Pressure Reducing Valve - 15-50 mm - Threaded
43 41 16.16.A	Tank - Cylinder
43 41 16.16.B	Water Heater
48 16 13.A	End Suction Pump - Close Coupled

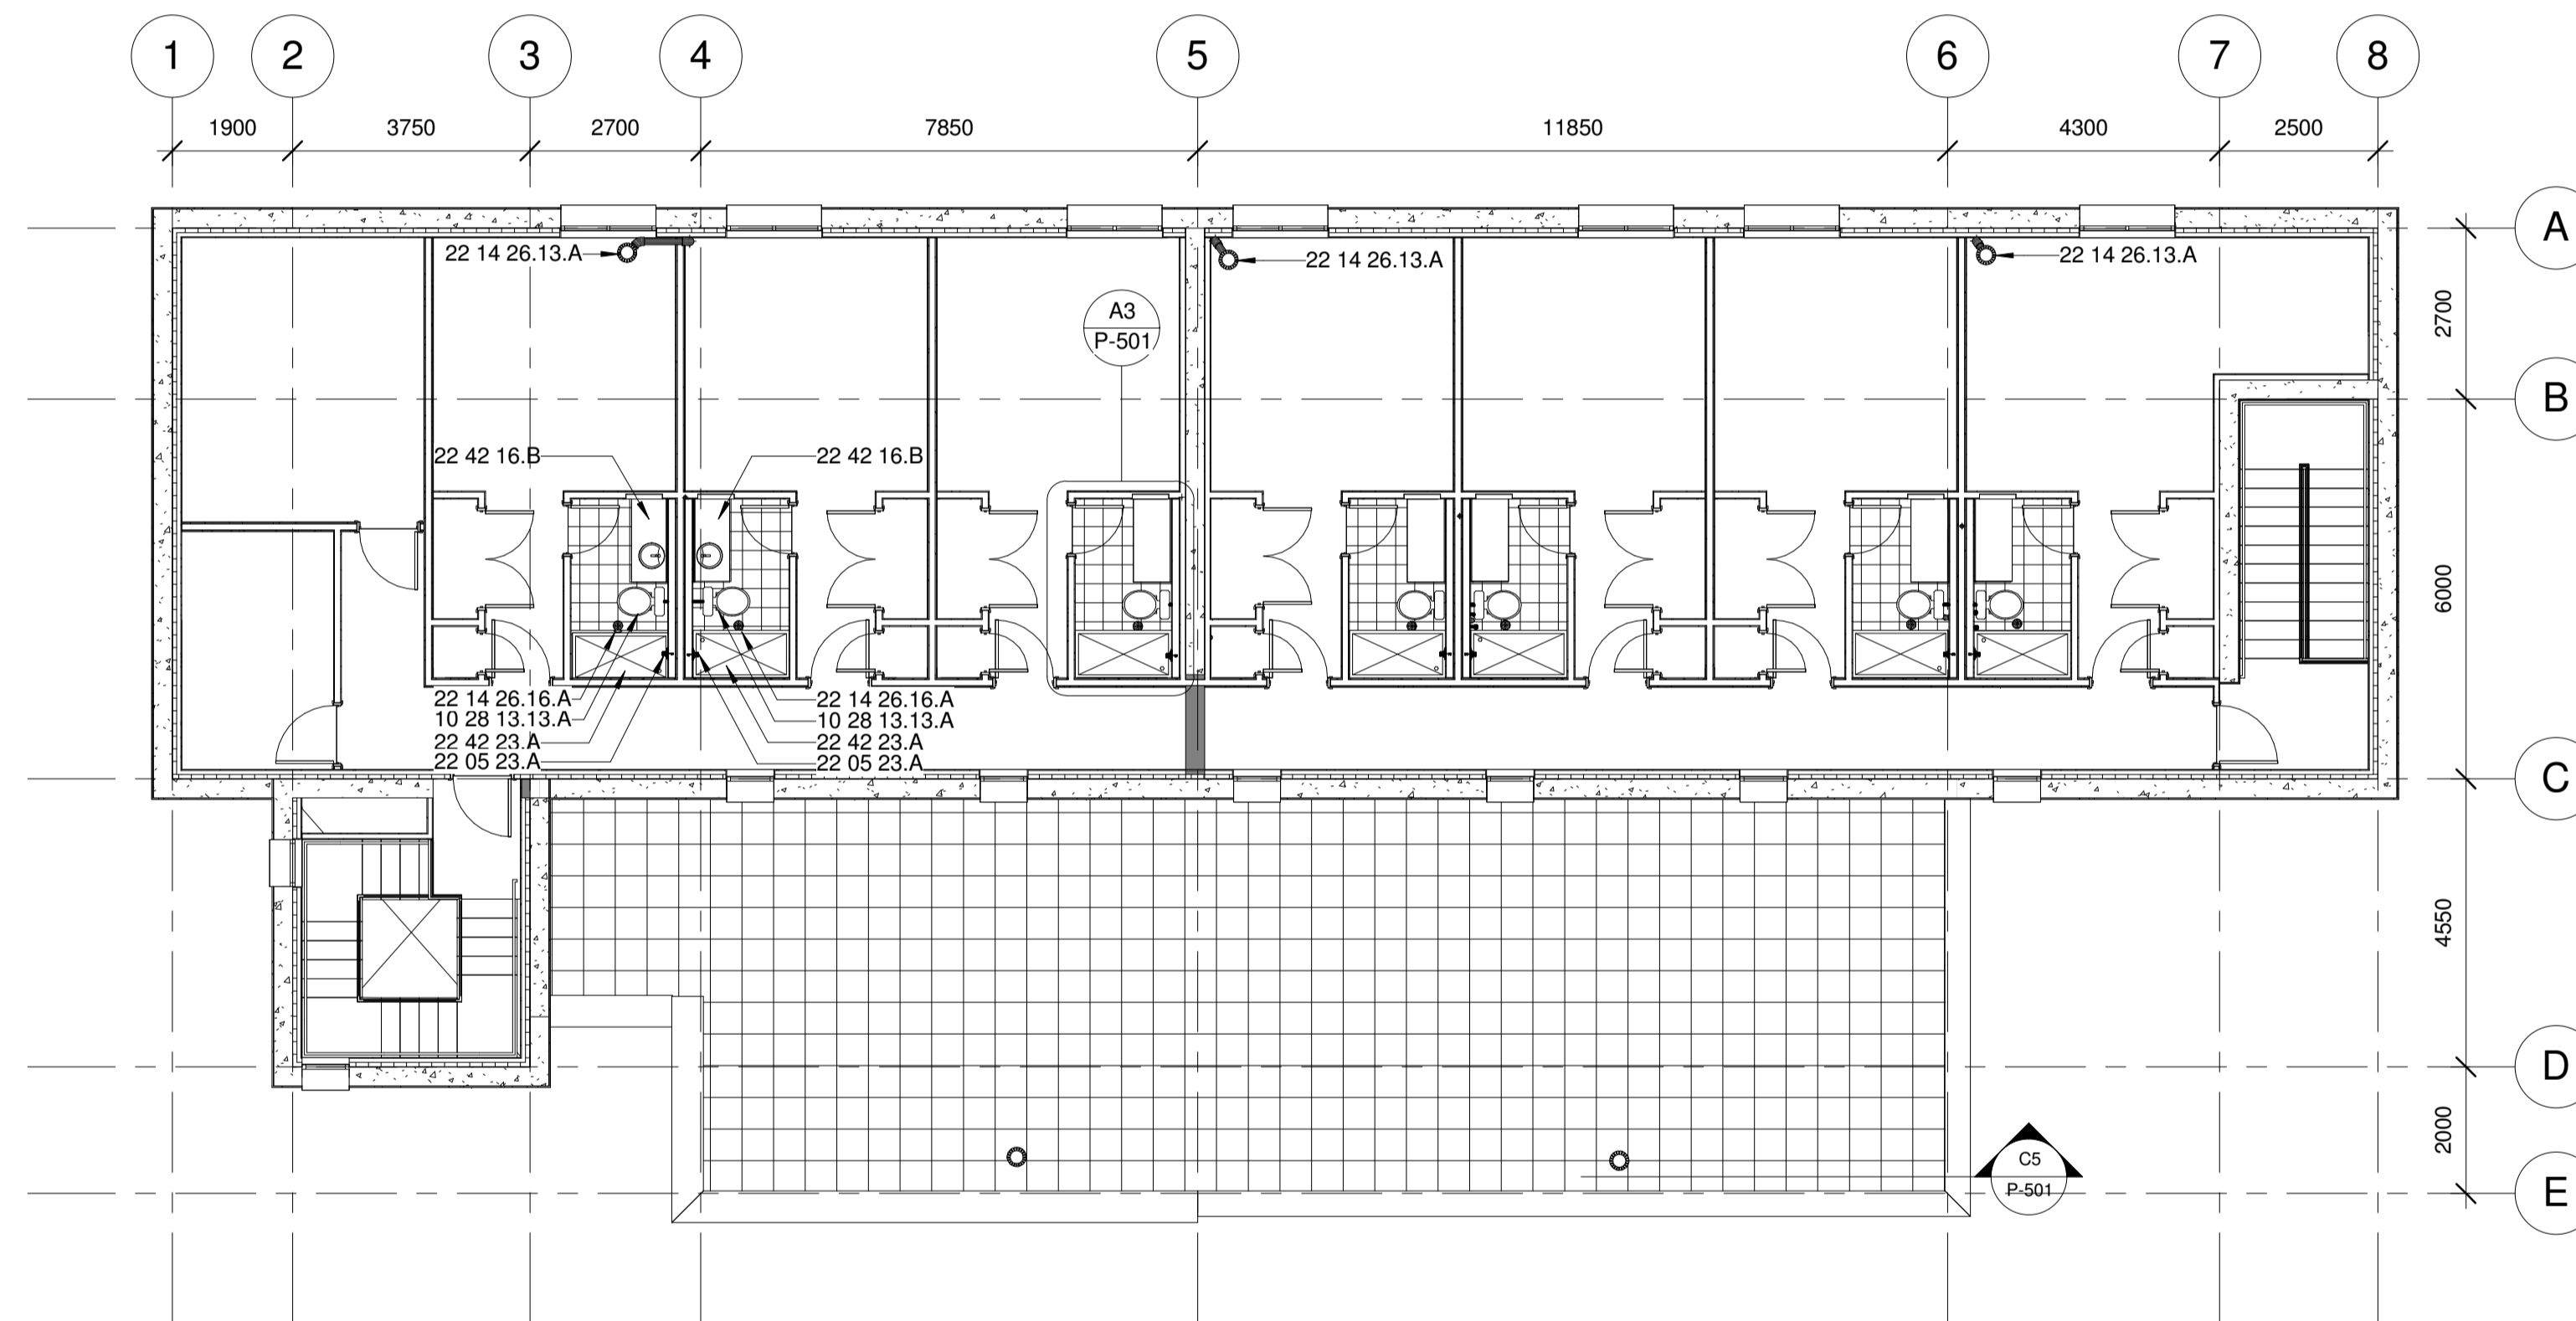

Level 2 - Full Height
1 : 100

THIS DESIGN IS NOT INTENDED TO MEET THE BUILDING CODES OR REGULATIONS OF ANY SPECIFIC COUNTRY OR JURISDICTION.
SOME COMPONENTS HAVE BEEN OMITTED AS THE DESIGN WAS MODELLED EXCLUSIVELY USING OUT OF THE BOX REVIT FAMILIES.

REV	DATE	DESCRIPTION
3	26.07.17	Final Issue
2	07.07.17	Spaces Revised
1	13.06.17	Issued for Review

PROJECT NUMBER	East Dormitory
DRAWN BY	F.W.
CHECKED BY	B.E.
SCALE (@ A1)	1 : 100
DATE	05/29/17
STATUS	Final Issue
REVISION	3

PROJECT	Four Dormitory Complex
TITLE	Level 2 Floor Plan
SHEET	P-102
	SHEET 2 OF 4

THIS DRAWING IS THE PROPERTY OF MMA ENVIRONMENTAL AND SHALL NOT BE USED, REPRODUCED OR DISCLOSED TO ANYONE WITHOUT THE PRIOR WRITTEN PERMISSION OF MMA ENVIRONMENTAL.