



Keynote	Family
26 24 16.A	Security Panel
28 01 30.51.A	Intruder Security Alarm Sounder
28 13 00.A	Bell
28 13 00.B	Door Lock Magnetic
28 13 00.C	Release Button
28 13 00.D	Keypad
28 13 43.A	Access Card Reader
28 16 19.A	Wall Mounted Passive Infrared Detector
41 24 33.A	Magnetic Contact

Four Dormitory Complex  
East Healey Street,  
Champaign,  
Illinois,  
USA.

**Prairie Sky Consulting**

1104 Parkview Drive  
Mahomet  
Illinois  
USA 61853


Email: bill.east@prairieskyconsulting.com  
Phone: 309 - 807 - 1519  
Web: www.prairieskyconsulting.com/

REV	DATE	DESCRIPTION
6	26.07.17	Final Issue
5	03.07.17	Spaces Revised
4	27.06.17	Keynotes Revised
3	30.05.17	Drawing Revised as per comments
2	07.04.17	Revised Parameters as per comments
1	28.03.17	Issued for Review

PROJECT NUMBER	East Dormitory
DRAWN BY	R.K.
CHECKED BY	B.E.
SCALE (@ A1)	1 : 100
DATE	03/06/17
STATUS	Final Issue
REVISION	6

PROJECT	Four Dormitory Complex
TITLE	Level 1 Floor Plan
	TY101
	SHEET 1 OF 4

THIS DRAWING IS THE PROPERTY OF MMA ENVIRONMENTAL AND SHALL NOT BE USED, REPRODUCED OR DISCLOSED TO ANYONE WITHOUT THE PRIOR WRITTEN PERMISSION OF MMA ENVIRONMENTAL.

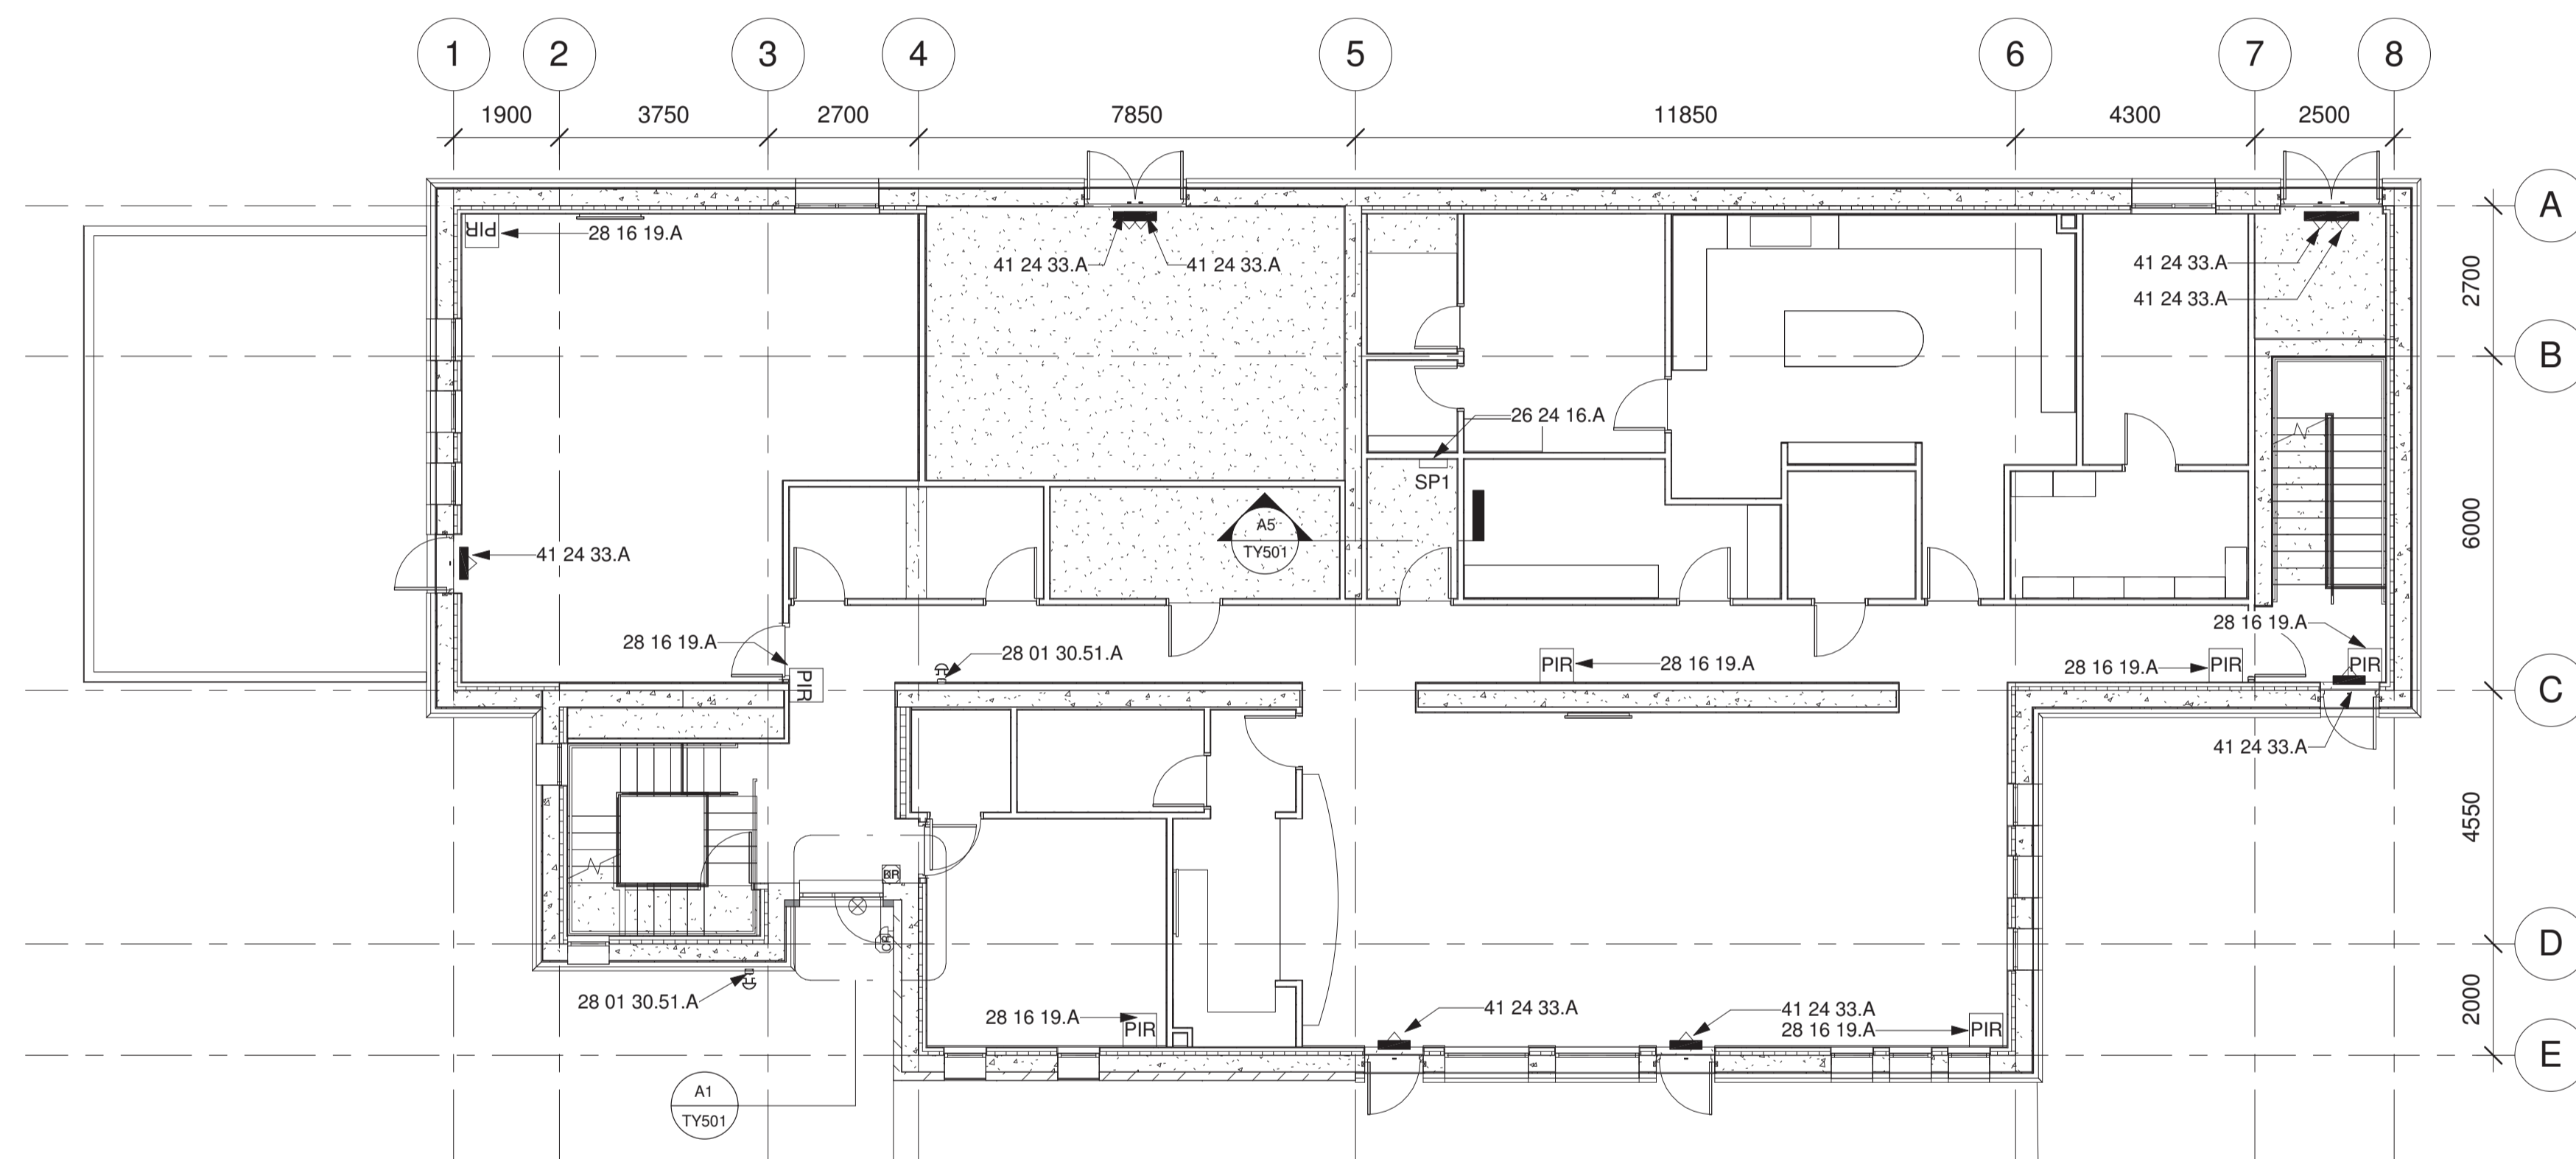

**Level 1 Floor Plan**  
1 : 100

THIS DESIGN IS NOT INTENDED TO MEET THE BUILDING CODES OR REGULATIONS OF ANY SPECIFIC COUNTRY OR JURISDICTION.

SOME COMPONENTS HAVE BEEN OMITTED AS THE DESIGN WAS MODELLED EXCLUSIVELY USING OUT OF THE BOX REVIT FAMILIES.