


MODELS, DRAWINGS AND SCHEDULES BASED ON NATIONAL INSTITUTE OF BUILDING SCIENCES buildingSMART ALLIANCE INFORMATION FOR BARRACKS 101 PROJECT WASHINGTON, DC, USA

NOTES  
This drawing contains the following files:

This drawing to be viewed in conjunction with:

xxxx Ceiling height AFFL (in mm)

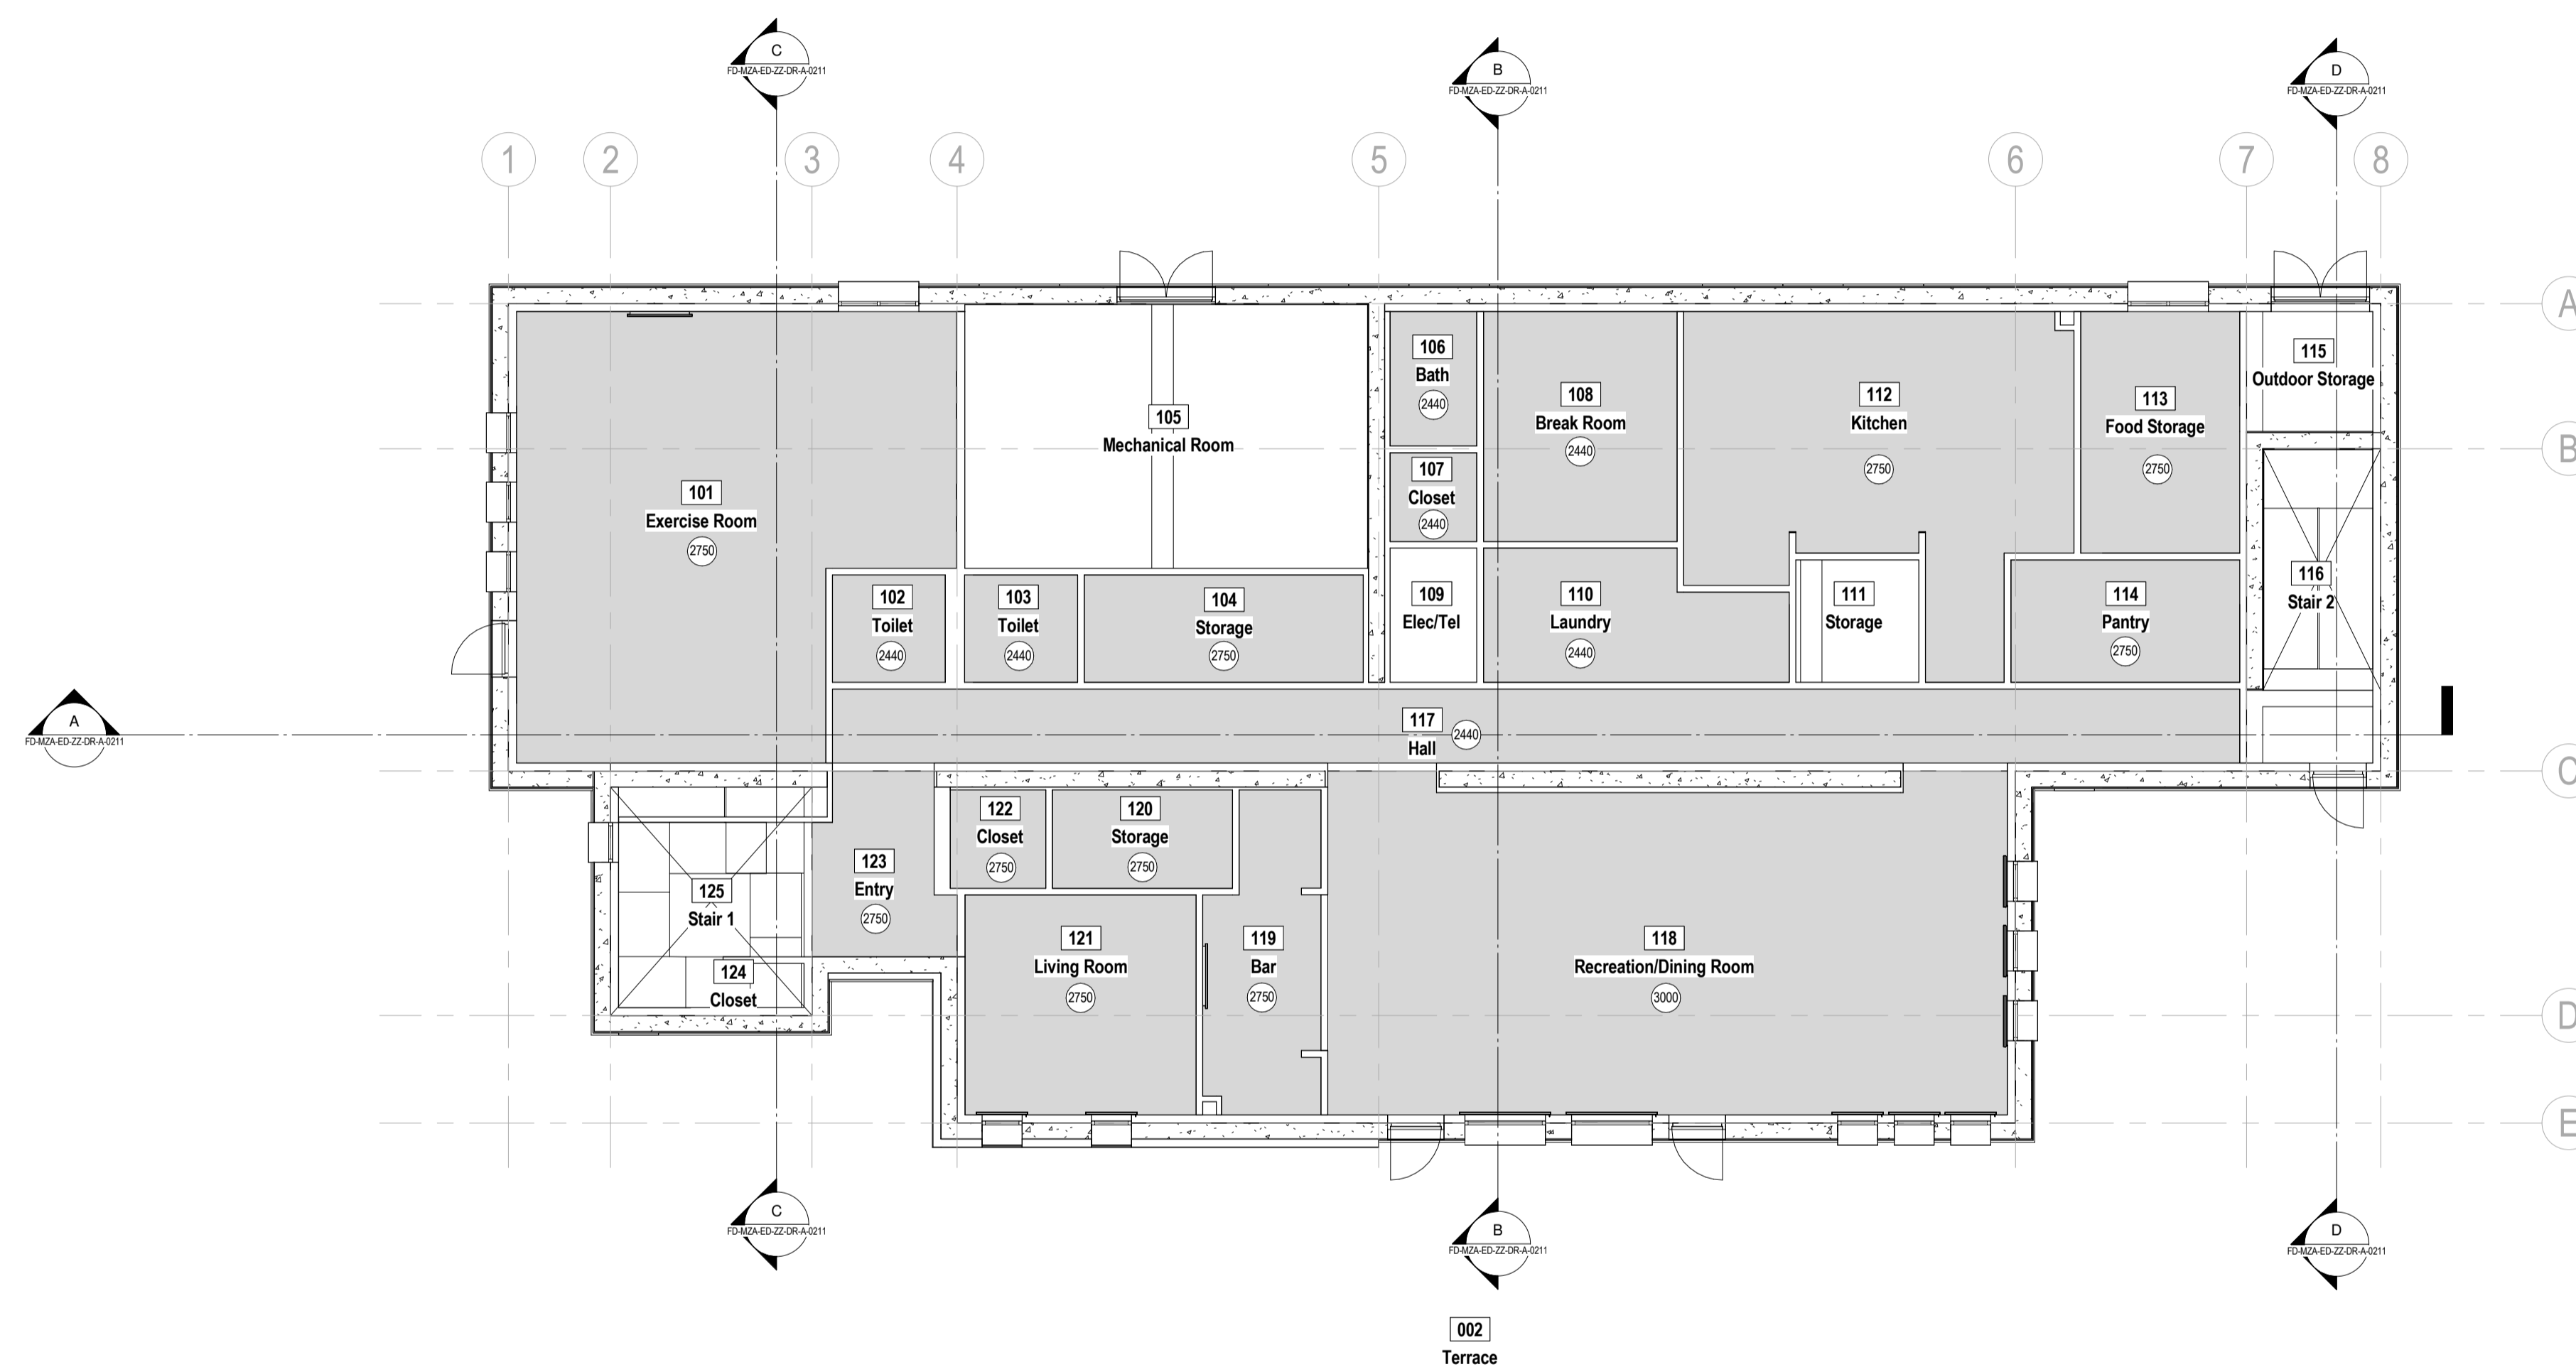

PI	02/01/17	Initial Issue	EH
Rev	Date	Comment	Drawn   Check
SCALE	1 : 100	@ A1	CONSULTANT PROJECT NUMBER n/a
MEASUREMENTS NOT TO BE OBTAINED BY SCALING ALL DIMENSIONS TO BE CHECKED ON SITE			
STATUS	SUITABLE FOR	INFORMATION	
 part of the fulcro group			
<small>© 2017 metz architects ltd B203, LCB Depot, 31 Rutland Street, Leicester, UK. LE1 1RE Tel: +44 (0) 116 261 6868 e-mail: <a href="mailto:mail@metz.uk.com">mail@metz.uk.com</a> Web: <a href="http://www.metz.uk.com">http://www.metz.uk.com</a></small>			
PROJECT	<b>Four Dormitory Complex</b> East Healey St, Champaign, IL East Dormitory		
TITLE	<b>Proposed Level 1 Reflected Ceiling Plan</b>		
CLIENT	Prairie Sky Consulting LLC <b>TEST PROJECT</b>		
DRAWING NUMBER	Project - Originator - Volume - Level - File Type - Role - Identifier	REVISION	
FD-MZA-ED-01-DR-A-0112		P1	

