


NOTES
This drawing contains the following files:

This drawing to be viewed in conjunction with:

xxxx Ceiling height AFFL (in mm)

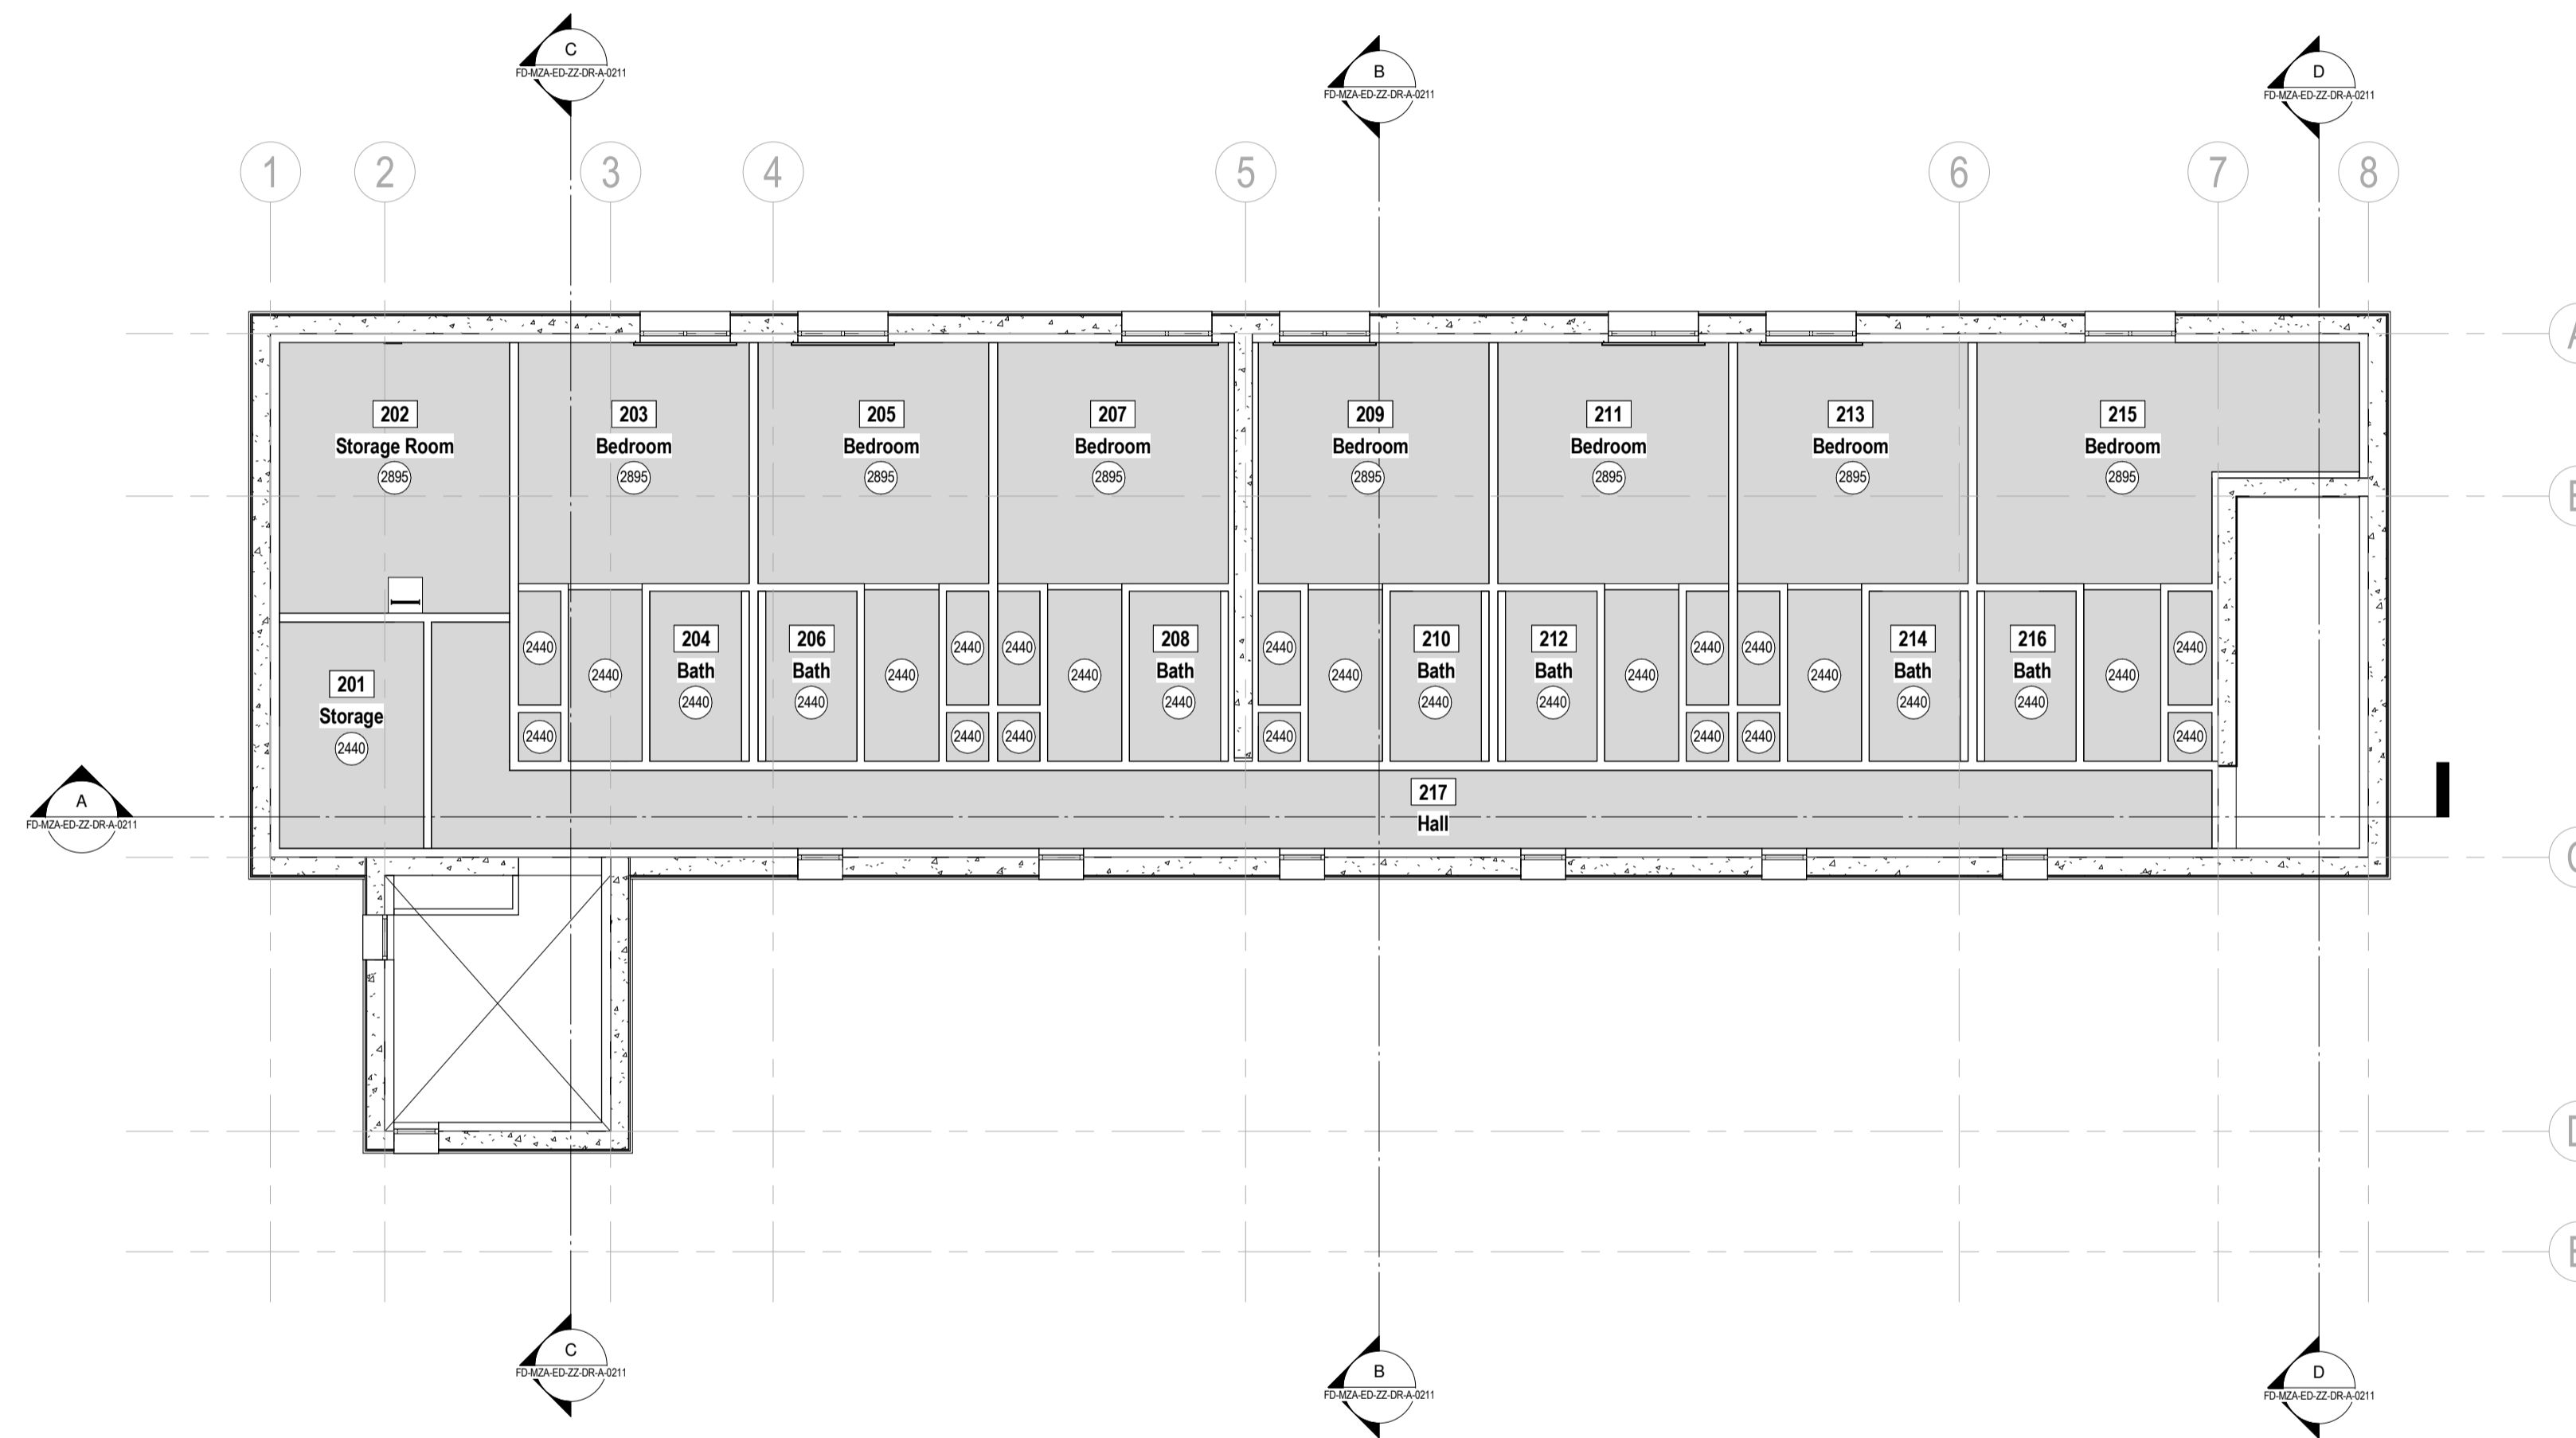

PI	02/07/17	Initial Issue	EH
Rev	Date	Comment	Drawn Check

SCALE	1 : 100	@ A1	CONSULTANT PROJECT NUMBER	n/a
-------	---------	------	---------------------------	-----

MEASUREMENTS NOT TO BE OBTAINED BY SCALING
ALL DIMENSIONS TO BE CHECKED ON SITE

STATUS	SUITABLE FOR	INFORMATION
--------	--------------	-------------

metzarchitects
part of the fulcro group

© 2017 metz architects ltd
B203, LCB Depot, 31 Rutland Street, Leicester, UK, LE1 1RE
Tel: +44 (0) 116 261 6868 e-mail: mail@metz.uk.com Web: <http://www.metz.uk.com>

PROJECT
Four Dormitory Complex
East Healey St, Champaign, IL
East Dormitory

TITLE
Proposed Level 2 Reflected Ceiling Plan

CLIENT
Prairie Sky Consulting LLC
TEST PROJECT

DRAWING NUMBER	REVISION
Project - Originator - Volume - Level - File Type - Role - Identifier	
FD-MZA-ED-02-MD-A-0112	P1

