


MODELS, DRAWINGS AND SCHEDULES BASED ON NATIONAL INSTITUTE OF BUILDING SCIENCES buildingSMART ALLIANCE INFORMATION FOR BARRACKS 101 PROJECT WASHINGTON, DC, USA

NOTES
This drawing contains the following files:

This drawing to be viewed in conjunction with:
FD-MZA-ED-ZZ-DR-A-0111 Proposed Building Elevations
FD-MZA-ED-ZZ-DR-A-0211 Proposed Building Sections

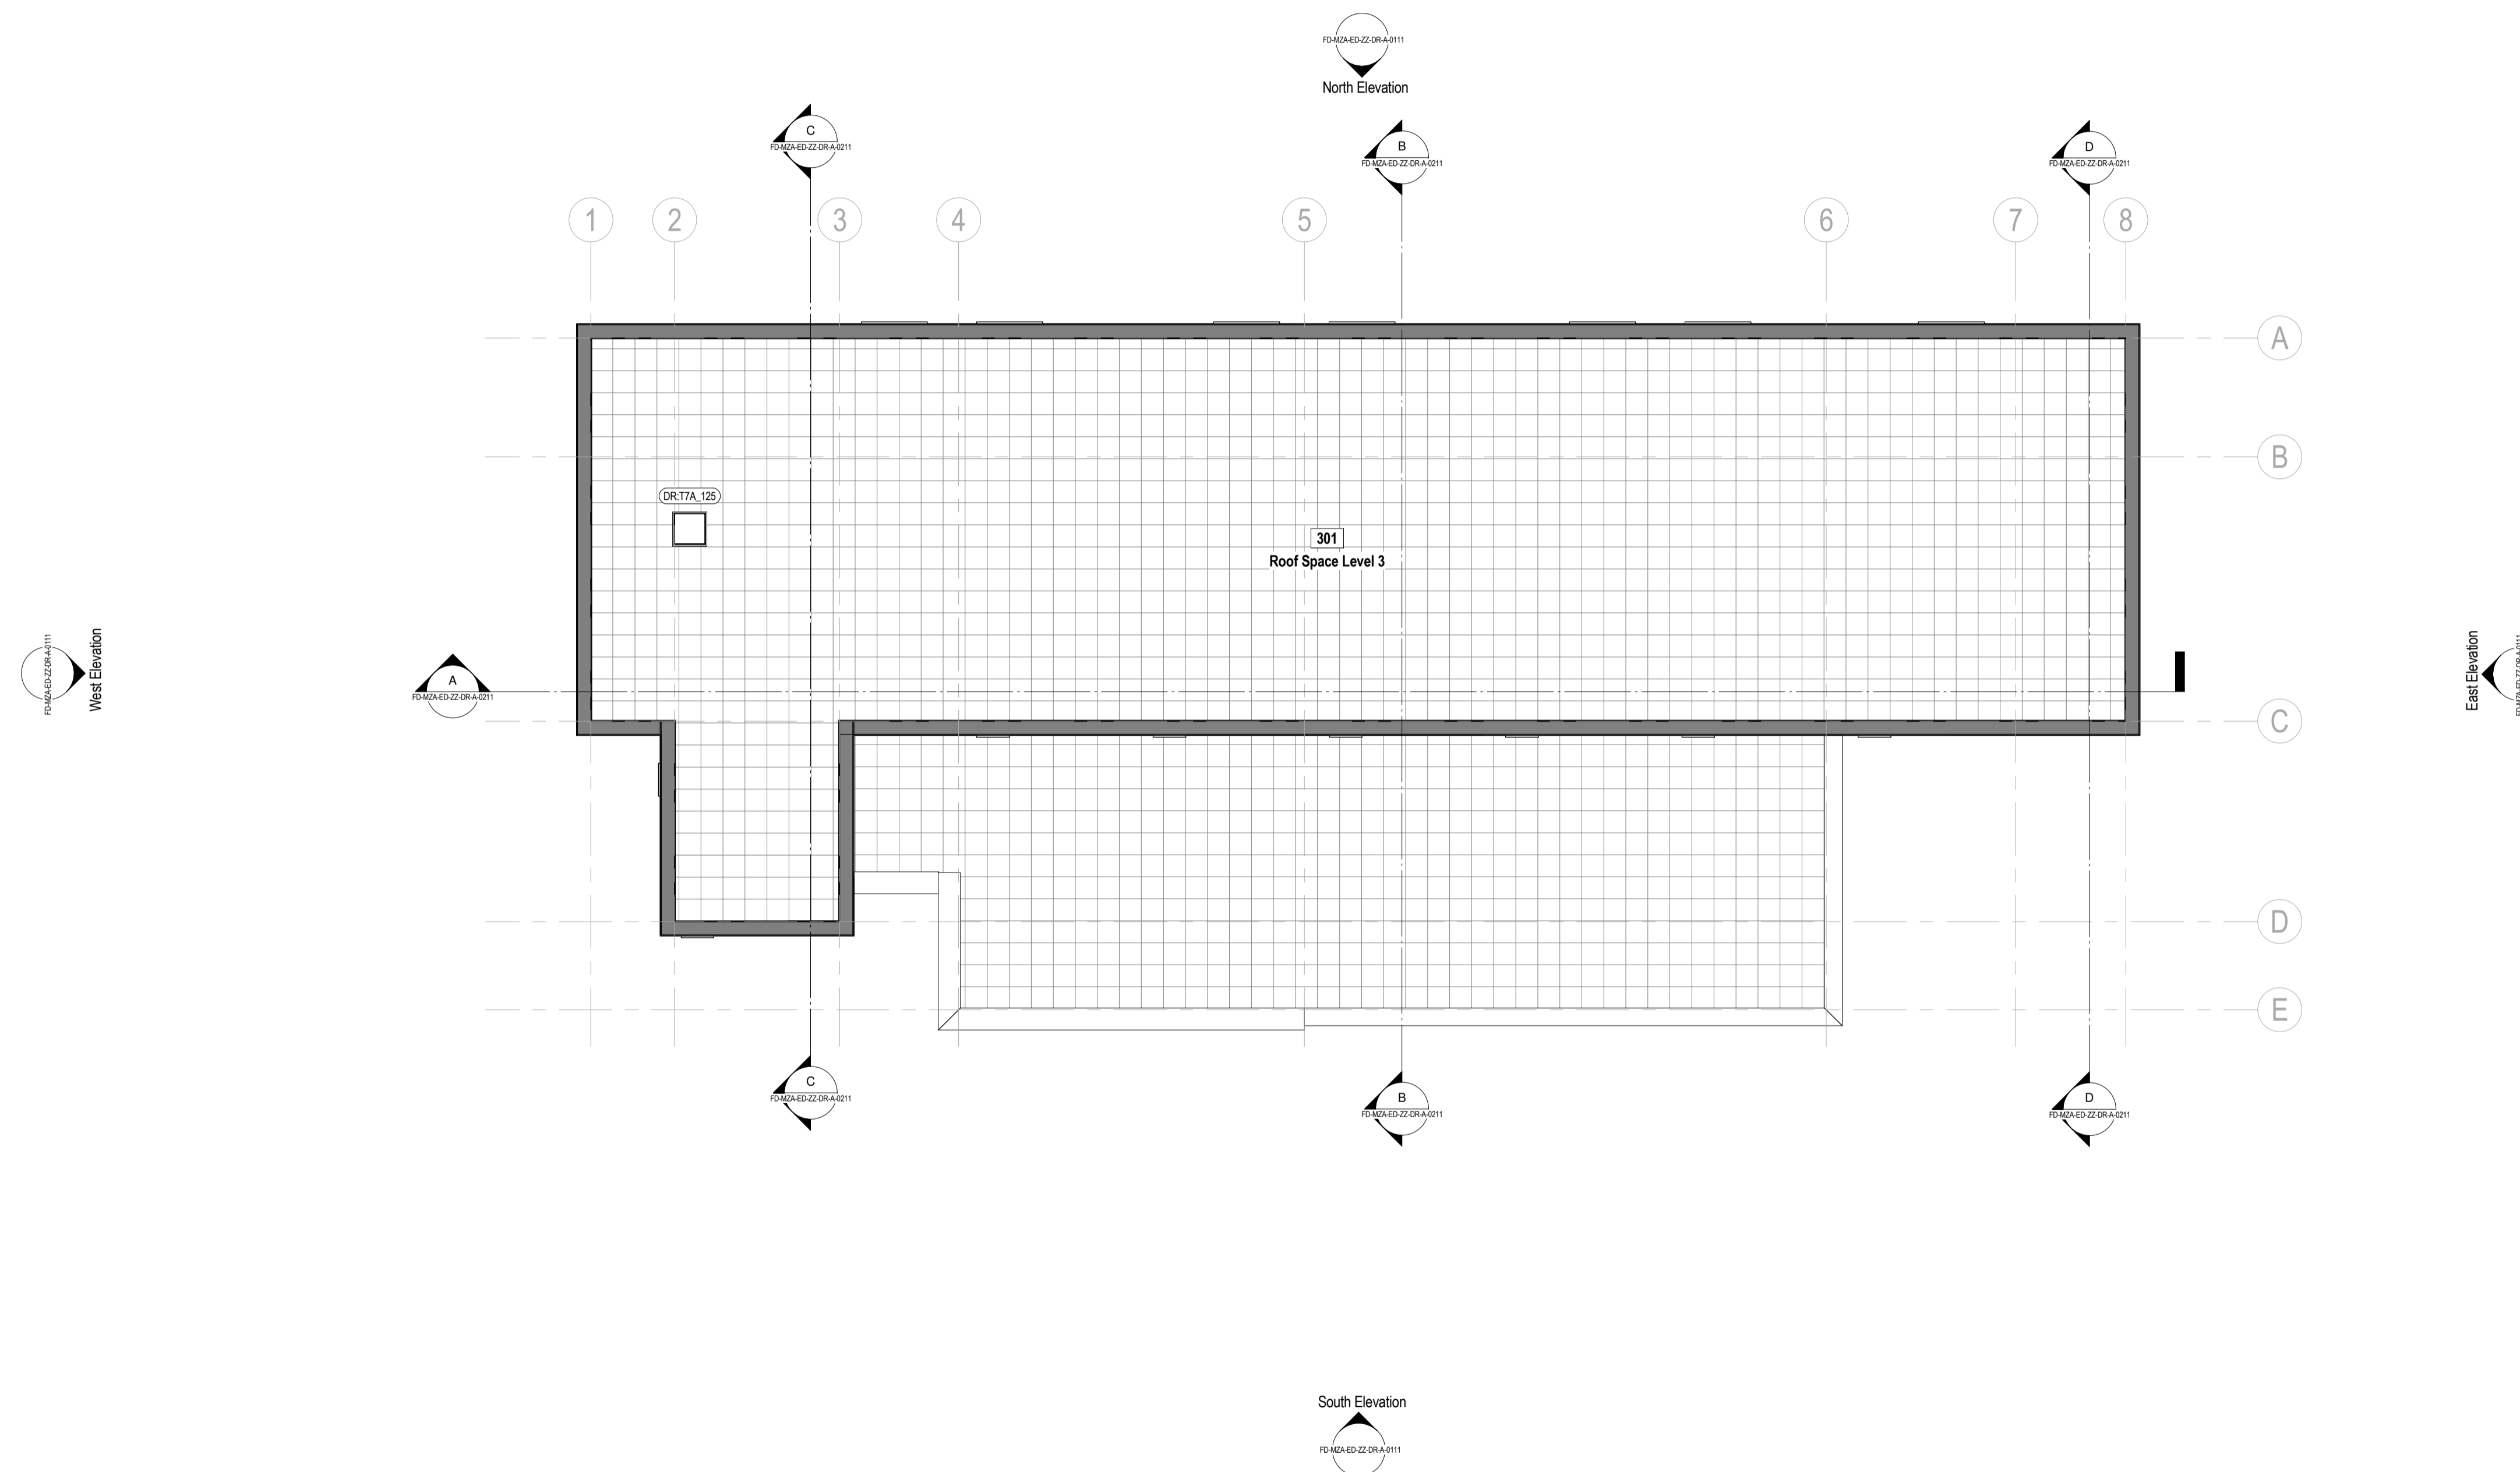

PI	02/07/17	Initial Issue	EH
Rev	Date	Comment	Drawn Check
SCALE	1 : 100	@ A1	CONSULTANT PROJECT NUMBER n/a
MEASUREMENTS NOT TO BE OBTAINED BY SCALING ALL DIMENSIONS TO BE CHECKED ON SITE			
STATUS	SUITABLE FOR	INFORMATION	
S2			
 part of the fulcro group			
<small>© 2017 metz architects ltd B203, LCB Depot, 31 Rutland Street, Leicester, UK, LE1 1RE Tel: +44 (0) 116 261 6868 e-mail: mail@metz.uk.com Web: http://www.metz.uk.com</small>			
PROJECT	Four Dormitory Complex East Healey St, Champaign, IL East Dormitory		
TITLE	Proposed GA Roof Plan		
CLIENT	Prairie Sky Consulting LLC TEST PROJECT		
DRAWING NUMBER	Project - Originator - Volume - Level - File Type - Role - Identifier	REVISION	
FD-MZA-ED-RF-DR-A-0111		P1	

