



NOTES
This drawing contains the following files:


This drawing to be viewed in conjunction with:
FD-MZA-ED-01-DR-A-0111 Proposed Level 1 GA Plan
FD-MZA-ED-02-DR-A-0111 Proposed Level 2 GA Plan
FD-MZA-ED-RF-DR-A-0111 Proposed GA Roof Plan

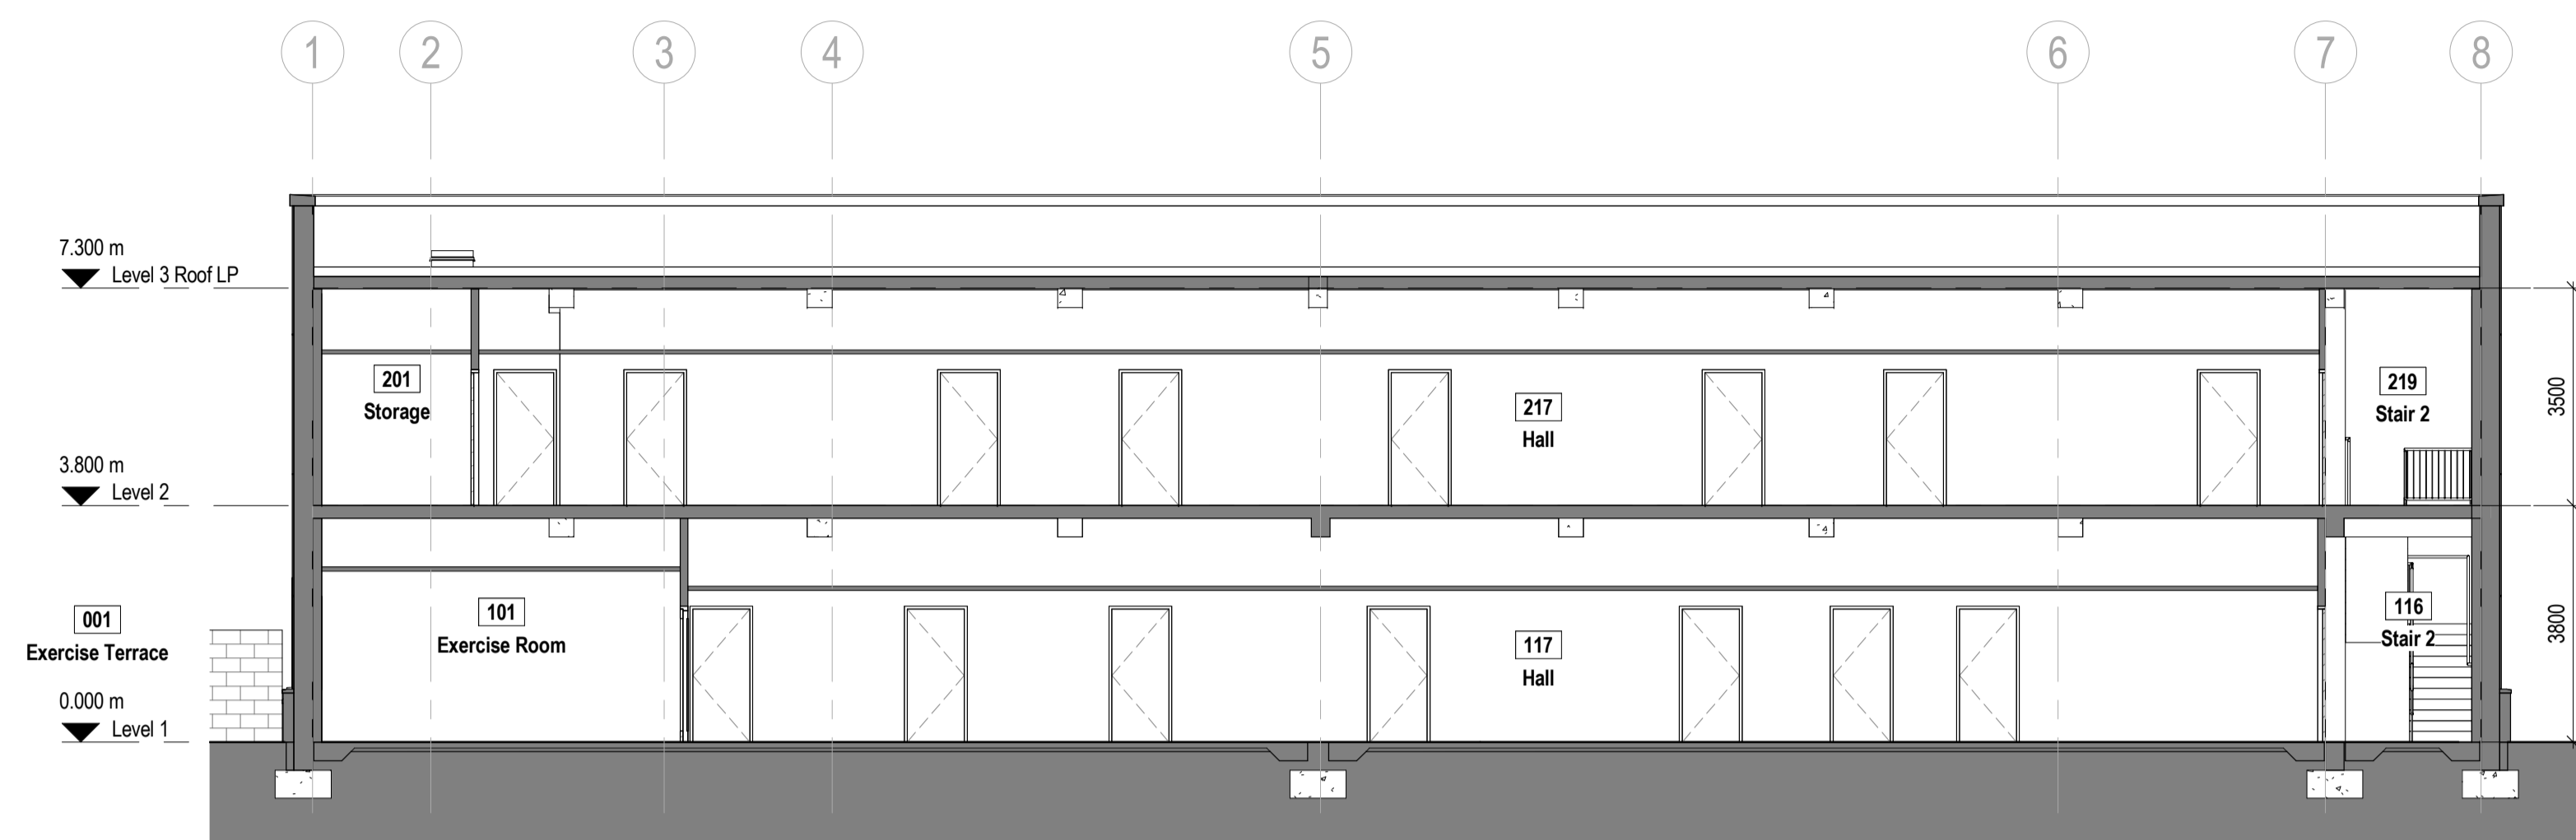


A Building Section AA

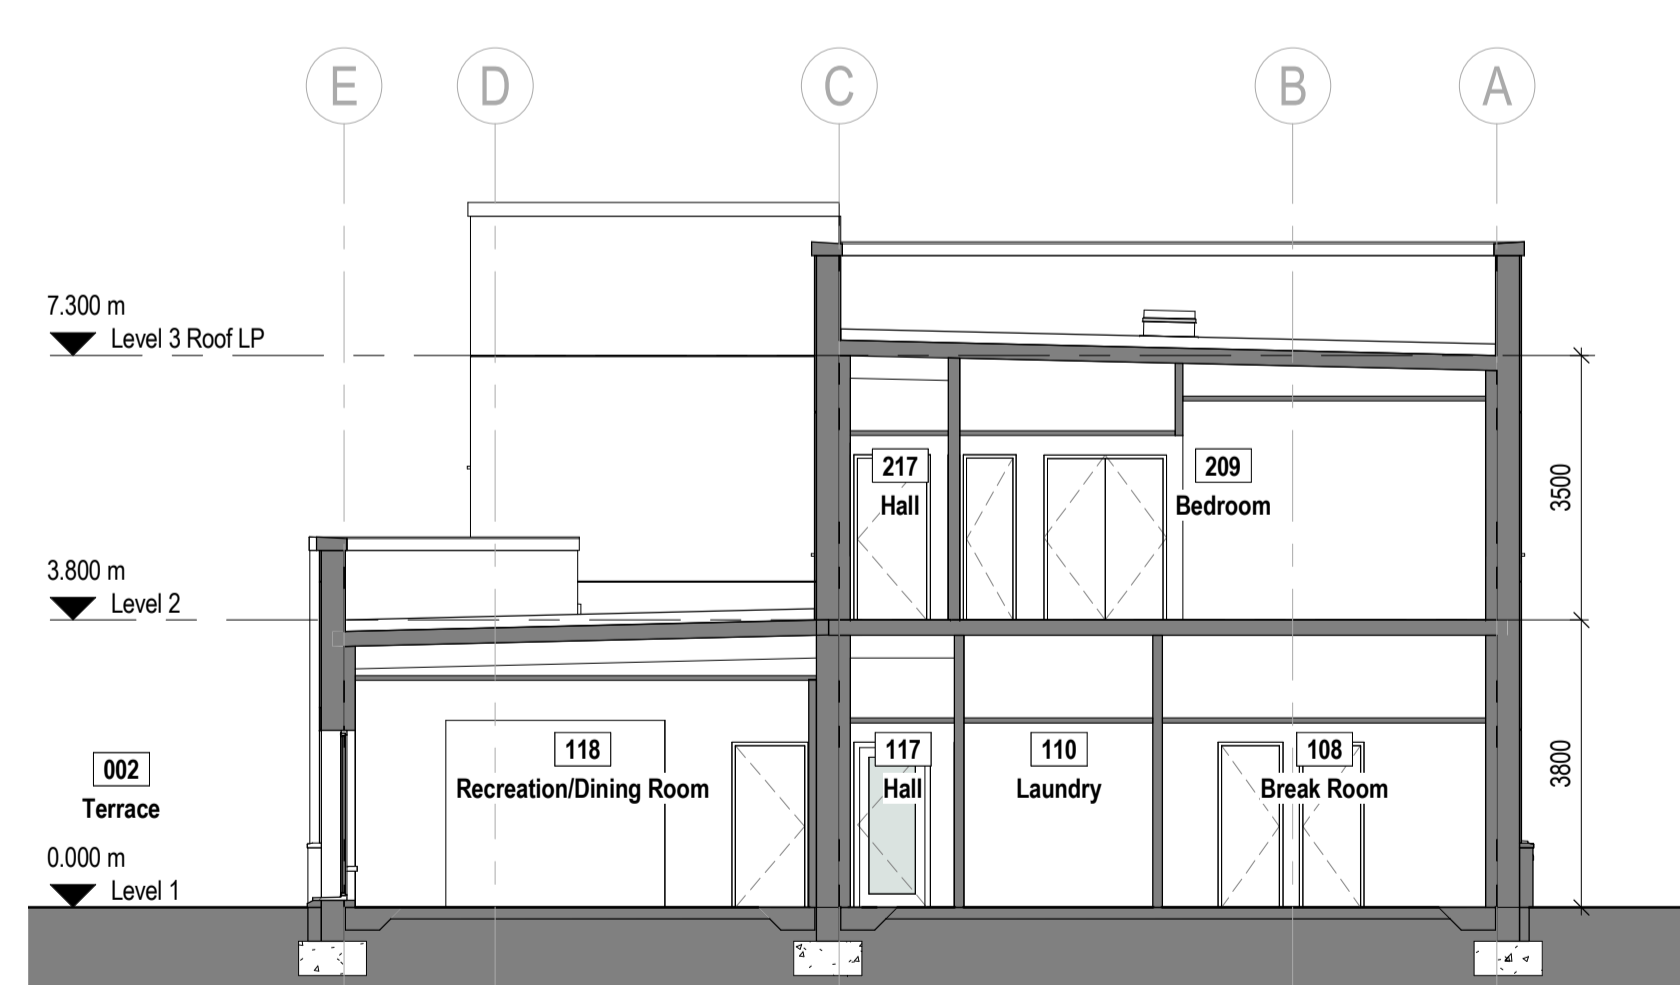

B Building Section BB

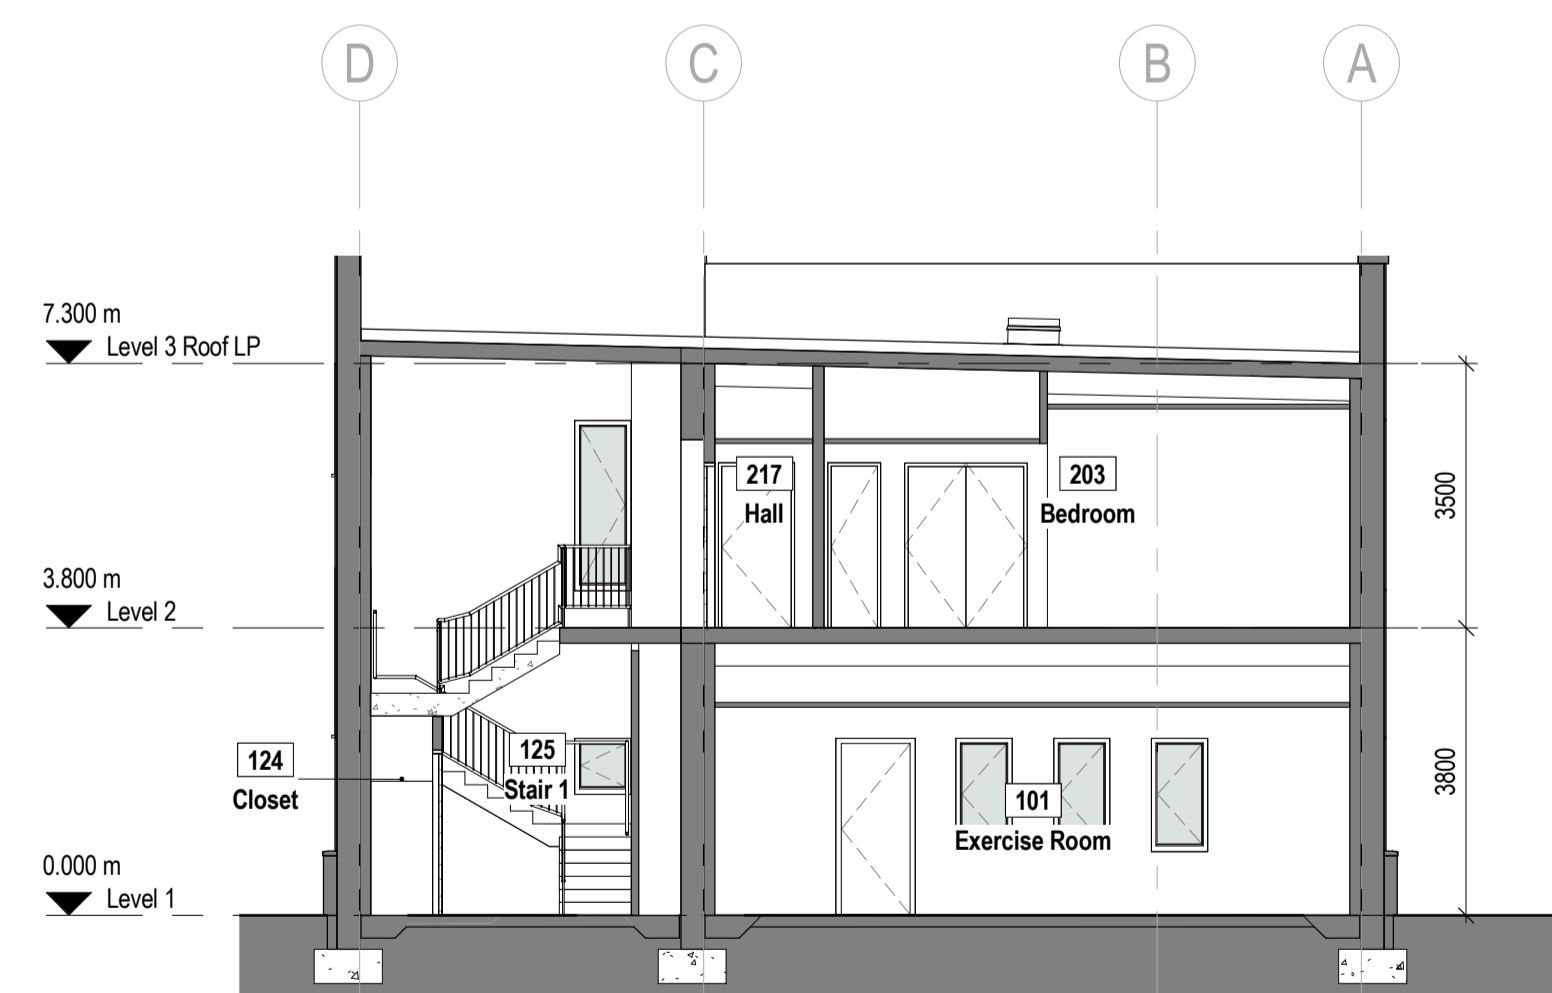

C Building Section CC

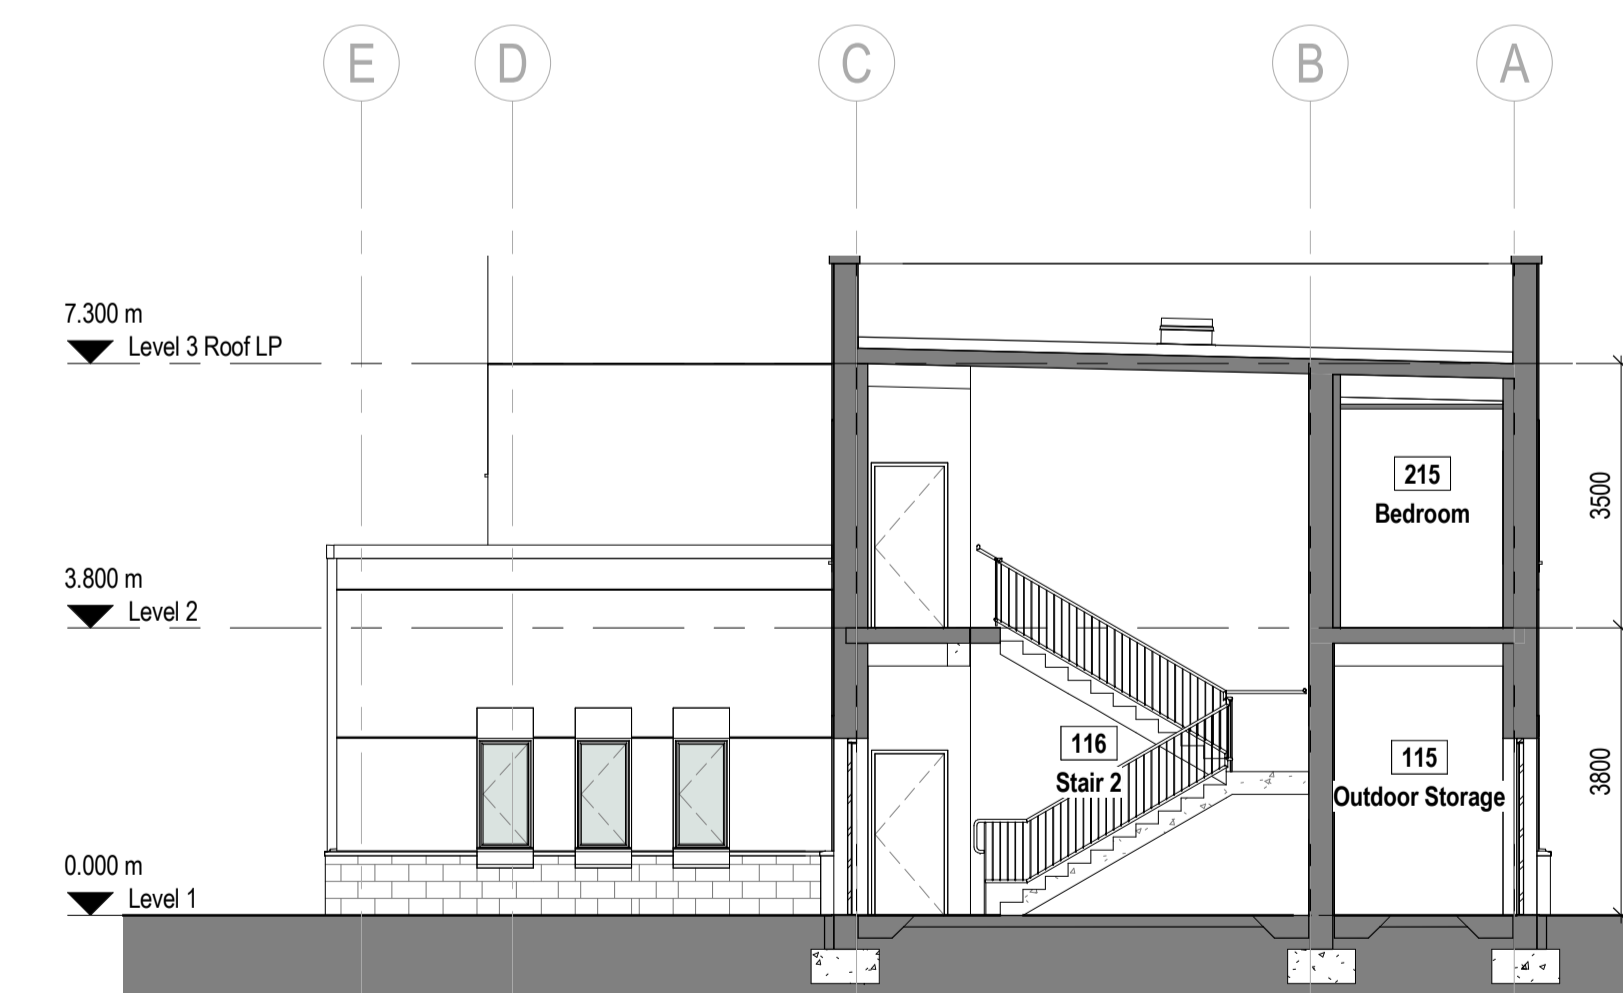

D Building Section DD

PI	02/07/17	Initial Issue	EH	EH
Rev	Date	Comment	Drawn	Check
SCALE	1 : 100	@ A1	CONSULTANT PROJECT NUMBER	n/a

MEASUREMENTS NOT TO BE OBTAINED BY SCALING
ALL DIMENSIONS TO BE CHECKED ON SITE

STATUS SUITABLE FOR

metzarchitects
part of the fulcro group

© 2017 metz architects ltd
B203, LCB Depot, 31 Rutland Street, Leicester, UK. LE1 1RE
Tel: +44 (0) 116 261 6868 e-mail: mail@metz.uk.com Web: <http://www.metz.uk.com>

PROJECT
Four Dormitory Complex
East Healey St, Champaign, IL
East Dormitory

TITLE
Proposed Building Sections

CLIENT
Prairie Sky Consulting LLC
TEST PROJECT

DRAWING NUMBER	REVISION
Project - Originator - Volume - Level - File Type - Role - Identifier	
FD-MZA-ED-ZZ-DR-A-0211	P1

